




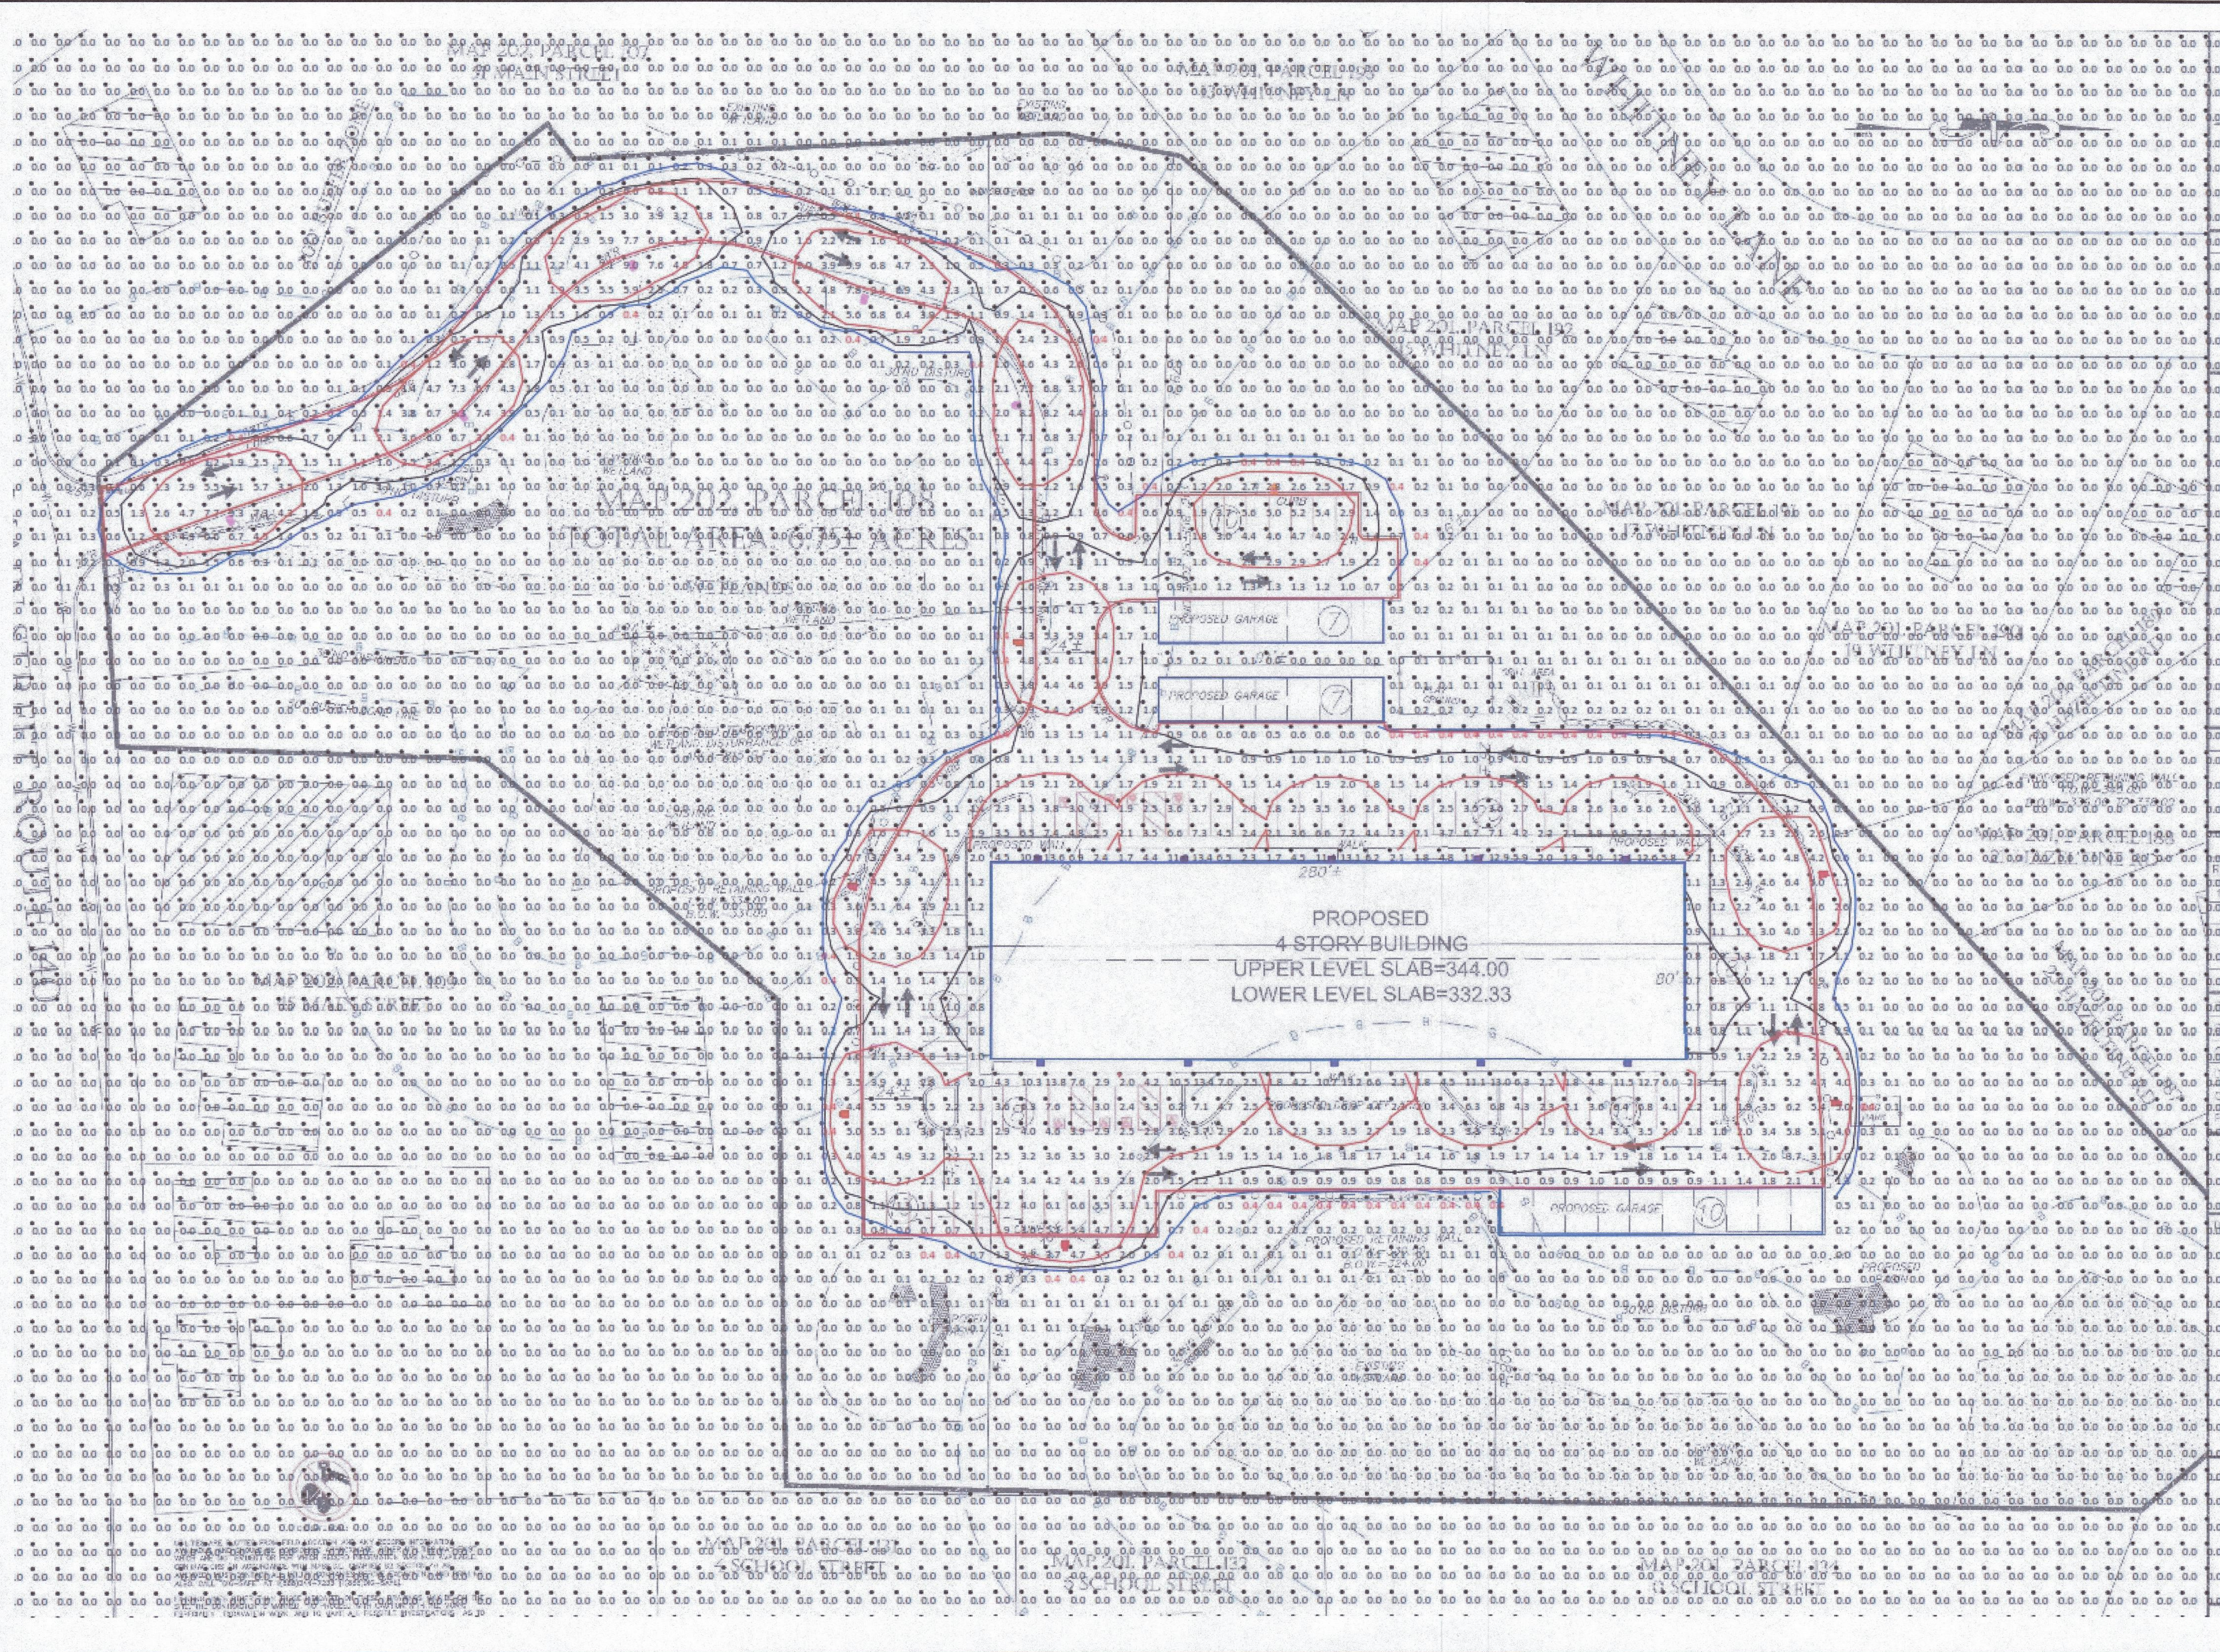


D&L Design Group
Civil Engineering & Land Surveying
115 Water Street • Milford, MA 01757
P:(508) 408-2577
www.dandlgroup.com

P.E.

P.L.S.

 GRAPHIC SCALE



(IN FEET)
1 inch = 30 feet

REVISIONS

REV.	DATE	DESCRIPTION

PROJECT NO.

J-016

DESIGNED BY

PML

CHECKED BY

MD

DATE

9/13/23

CAD FILE

J-016 SITE PLAN

PLAN NO.

APPLICANT/DEVELOPER:

LOBISSER BUILDING CORP.
1 Charlesview Road • Hopedale, MA 01747
P:(508) 478-6235

TITLE:

Upton Apartments
47 Main Street,
Upton Massachusetts
Preliminary
Residential Development Plans
Comprehensive Permit Application
Upton Zoning Board of Appeals

SHEET TITLE

LIGHTING PLAN

SHEET NO.

C-10.1

Luminaire Schedule							
All quotes/orders generated from this layout must be forwarded to the Local Rep Agency							
Symbol	Qty	Tag	Label	Arrangement	LLF	Description	BUG Rating
	5	A2	ALEDM2T	Single	1.000	ALEDM2T, 90W	B3-U0-G2
	1	A3	ALEDM3T	Single	1.000	ALEDM3T, 90W	B1-U0-G2
	6	A4	ALEDM4T	Single	1.000	ALEDM4T, 90W	B1-U0-G3
	10	S1	SLIM17FAFC100	Single	1.000	SLIM17FAFC100_5K at 0_ CCT Setting	B3-U0-G2



- **THE** light loss factor (LLF) is a product of many variables, often large lamp depreciation (LLD) has contributed to the calculated results unless otherwise noted. The LLF is the small (typical) of many numbers in initial lumens per watt (lamp manufacturer's) prediction.
- **ILLUMINATION** values shown (in footcandles) are the predicted results for plants of calculation. The number of footcandles and footcandle/foot is the same. More operation is normal in the place of calculation.
- **THE** calculated result of this lighting simulation **isn't** an anticipated prediction of system performance. Actual measured results may vary from the anticipated performance and we subject to many factors that are beyond our control.
- **Mounting height** determination is job site specific, our lighting simulation assumes a mounting height (inverted point) of the luminaire symbol to be taken at the top of the symbol for ceiling mounting and at the bottom of the symbol of the luminaire for floor mounting conditions.
- **THE** is the Owner's responsibility to confirm the suitability of the existing or proposed plants and to support the plants and the lighting of the plants. The lighting simulation is not a warranty, the owner is not conditions and wind zone. It is recommended that a professional engineer be trained in lighting simulation and lighting design.
- **THE** landscape material manufacturer is contractual, and is not intended to be an accurate representation of any particular plant, shrub, or tree, as these materials are living objects. The lighting simulation is not a warranty of the lighting simulation or the lighting simulation.
- **THE** actual illumination values measured in the field will vary.
- **PHOTOMETRIC** model elements such as buildings, windows, plants, fixtures or any architectural details which impact the disposition of light must be detailed by the customer documents to be used in the lighting simulation. The lighting simulation is not responsible for any measurement caused by incomplete information on the part of the customer, and reserves the right to be low level of lighting simulation.
- **RADI** Lighting Inc., luminaires and product designs are produced under U.S. and International intellectual property laws. Paying license or royalty apply.

HOLBROOK-ASSOCIATED

Need help? Tech help line: (888) 722-1000 Email: sales@zablighting.com Website: www.zablighting.com
Copyright © 2023 RAB Lighting All Rights Reserved. Note: Specifications are subject to change at any time without notice.


Need help? Tech help line: (888) 722-1000 Email: sales@rablighting.com Website: www.rablighting.com
Copyright © 2023 RAB Lighting All Rights Reserved Note: Specifications are subject to change at any time without notice

Need help? Tech help line: (888) 722-1000 Email: sales@rablighting.com Website: www.rablighting.com
Copyright © 2023 RAB Lighting All Rights Reserved. Note: Specifications are subject to change at any time without notice.

Need help? Tech help line: (888) 722-1000 Email: sales@nblighting.com Website: www.nblighting.com

Need help? Tech help line: (888) 722-5000 Email: sales@ablighting.com Website: www.ablighting.com
Copyright © 2023 RAB Lighting All Rights Reserved Note: Specifications are subject to change at any time without notice

P.E.	P.L.S.

 

APPLICANT/DEVELOPER:
LOBISSER BUILDING CORP.
1 Charlesview Road • Hopedale, MA 01747
P:(508) 478-6235

SHEET TITLE

SHEET NO.

C-10.2