



 
115 Water Street • Milford, MA 01757

P:(508) 408-2577

P.E.

P.L.S.

GRAPHIC SCALE



(IN FEET)

1 inch = 30 feet

REVISIONS

REV.	DATE	DESCRIPTION
1	1/8/24	REVISED PLANS.

PROJECT NO.	J-016
DESIGNED BY	PML
CHECKED BY	MD
DATE	9/13/23
CAD FILE	J-016 SITE PLAN
PLAN NO.	

APPLICANT/DEVELOPER:

LOBISSER BUILDING CORP.

1 Charlesview Road • Hopedale, MA 01747

P: (508) 478-6235

TITLE:

Upton Apartments

47 Main Street,
Upton Massachusetts


Preliminary
Residential Development Plans
Comprehensive Permit Application
Upton Zoning Board of Appeals

SHEET TITLE

LIGHTING PLAN


SHEET NO.

C-10.1

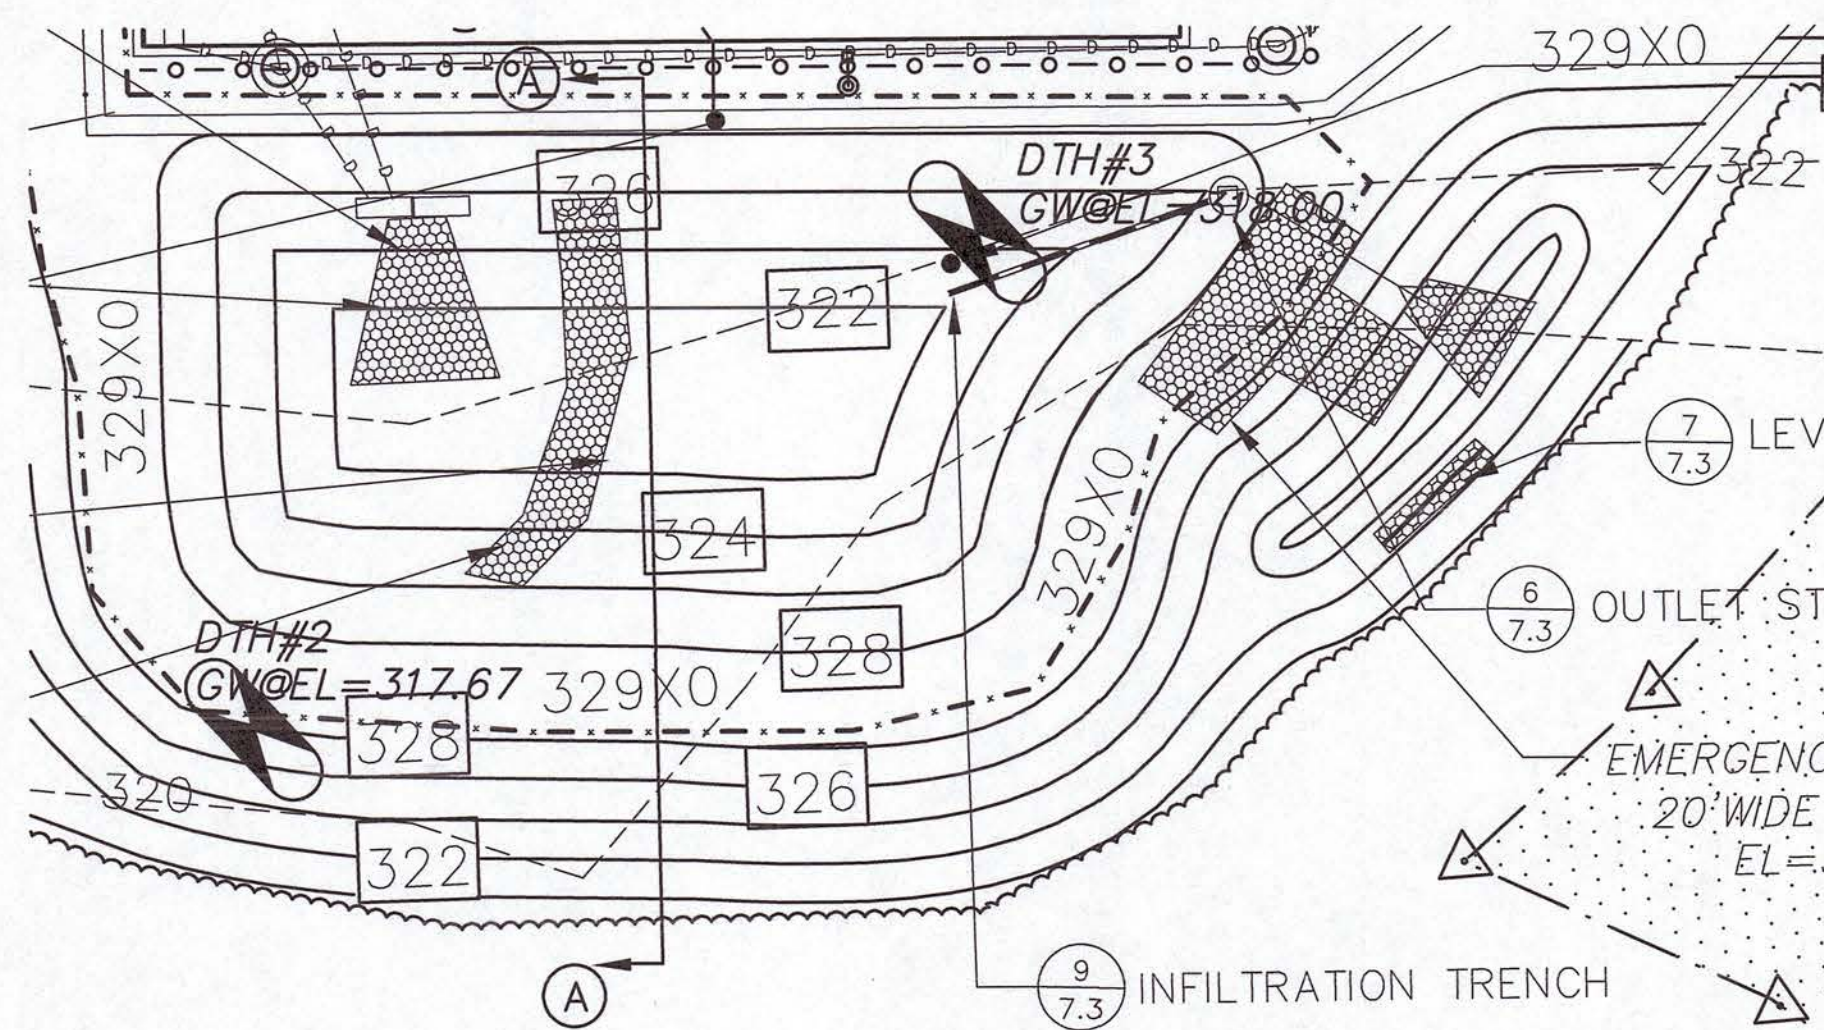


PLAIN VIEW FOR SECTION A - A

SCALE: 1"=20'

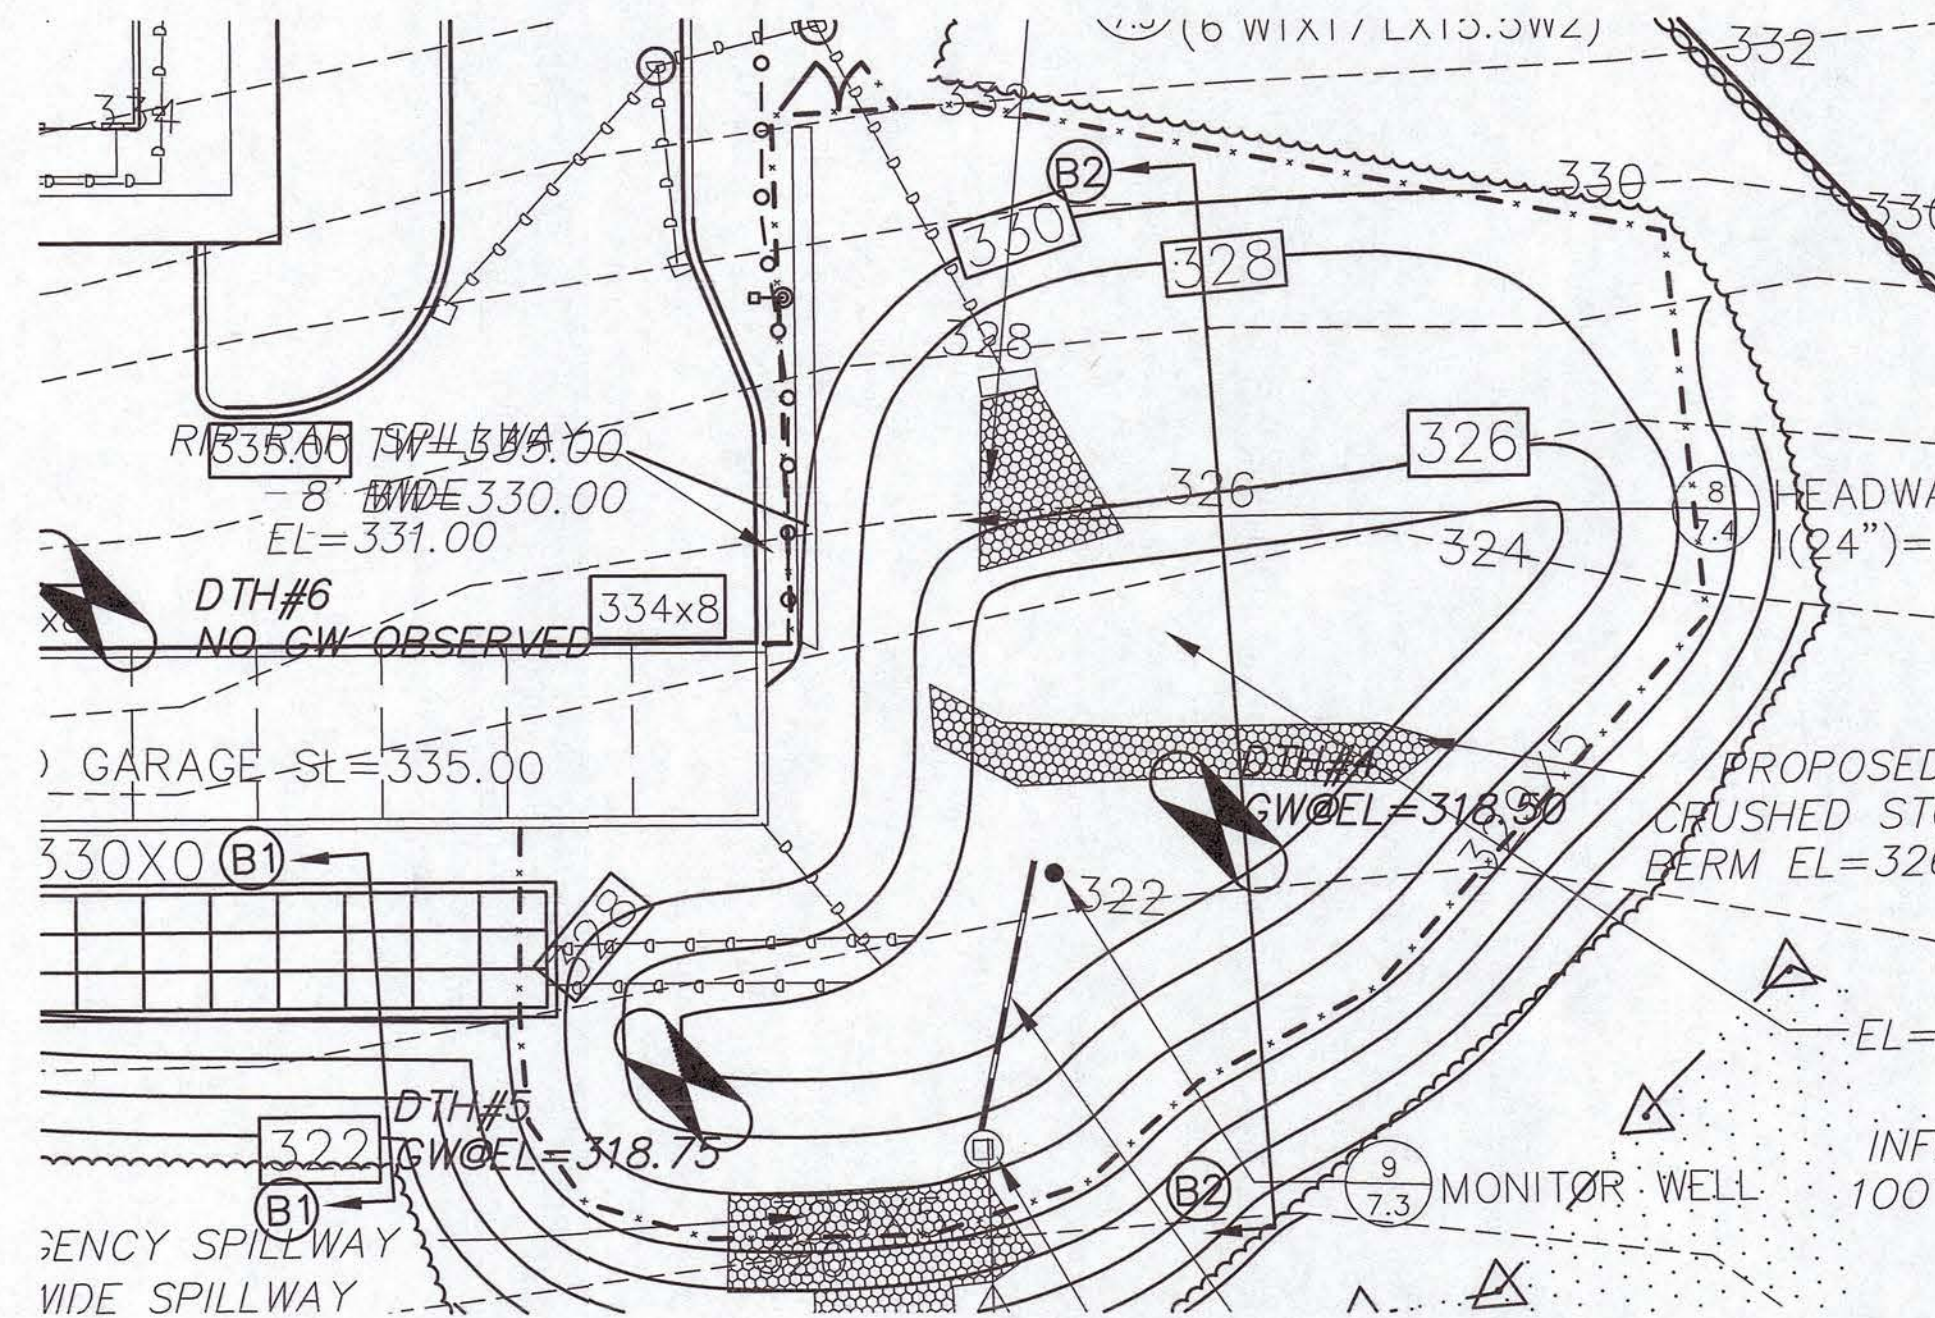


PLAIN VIEW FOR SECTION B-B

SCALE: 1"=20'

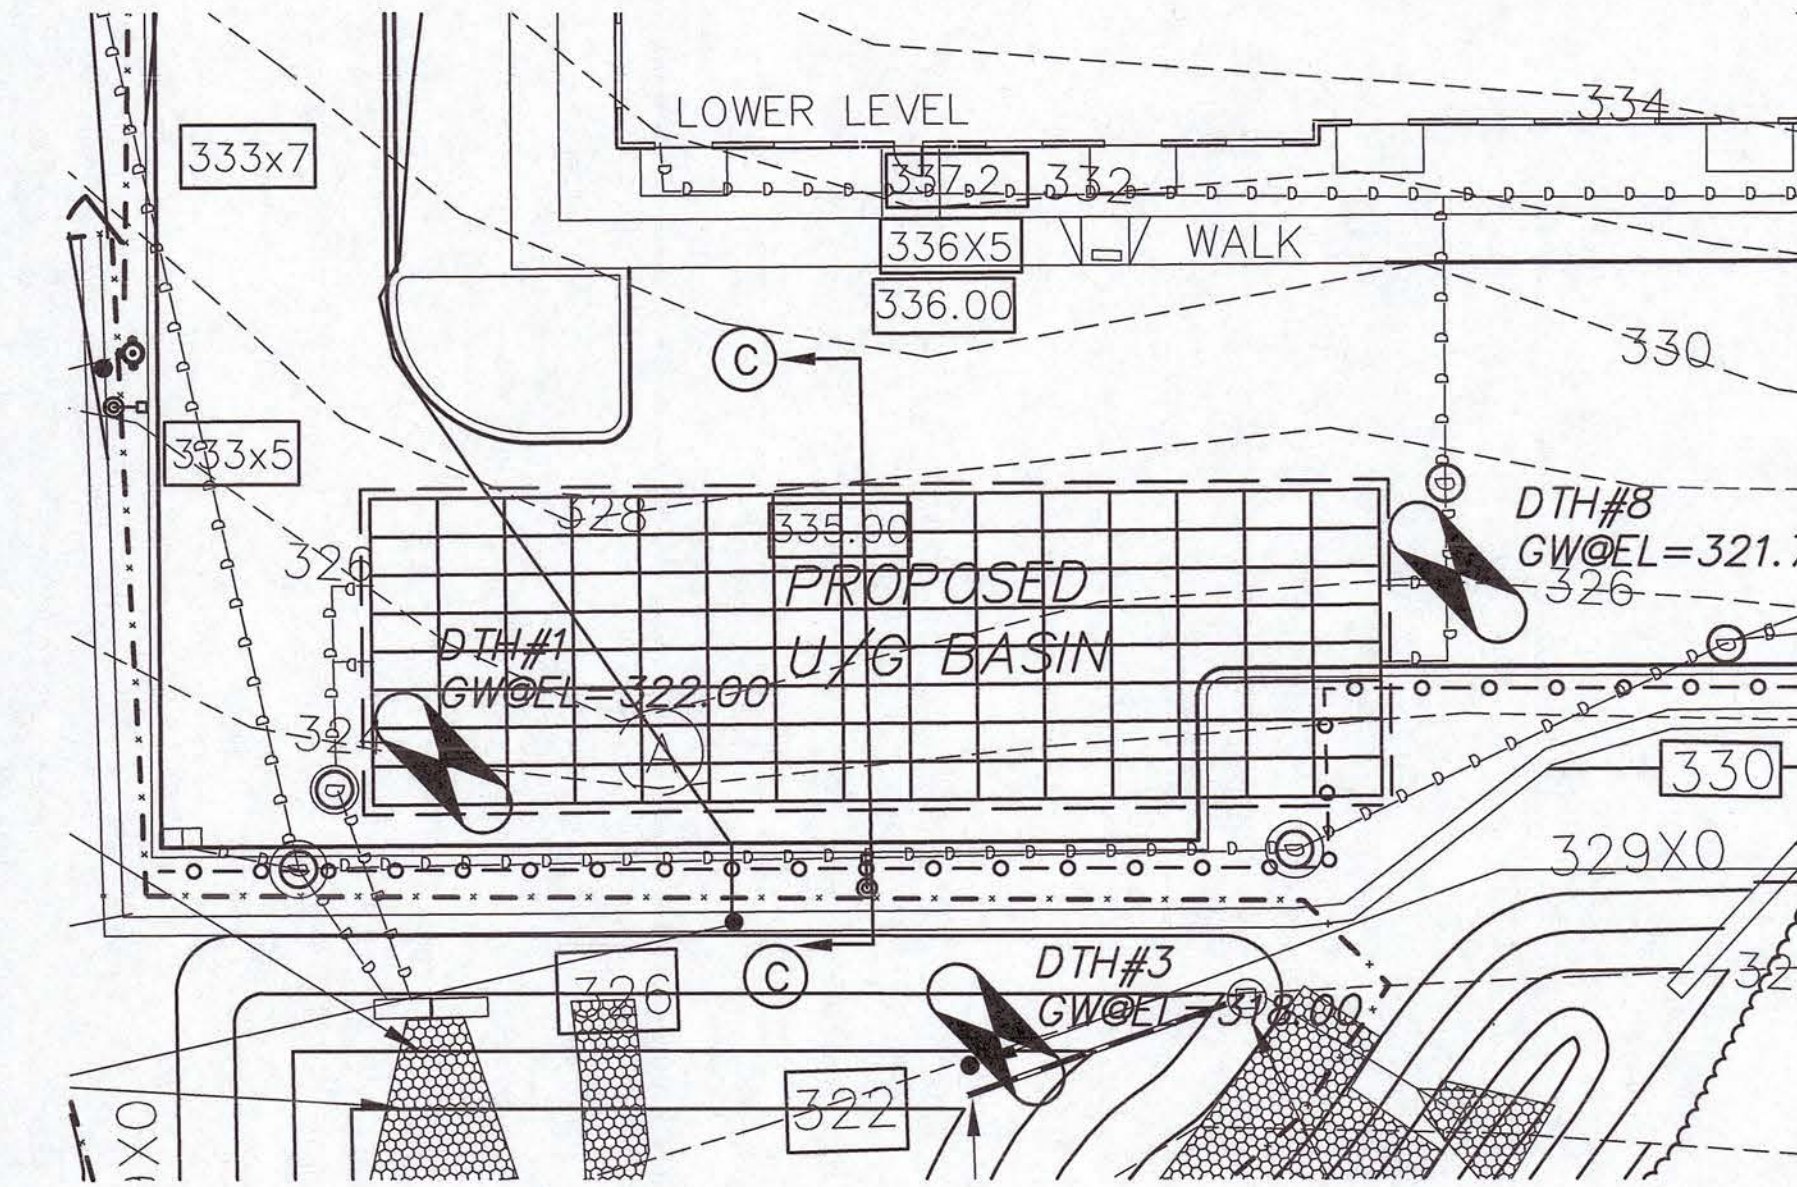


PLAIN VIEW FOR SECTION C-C

SCALE: 1"=20'

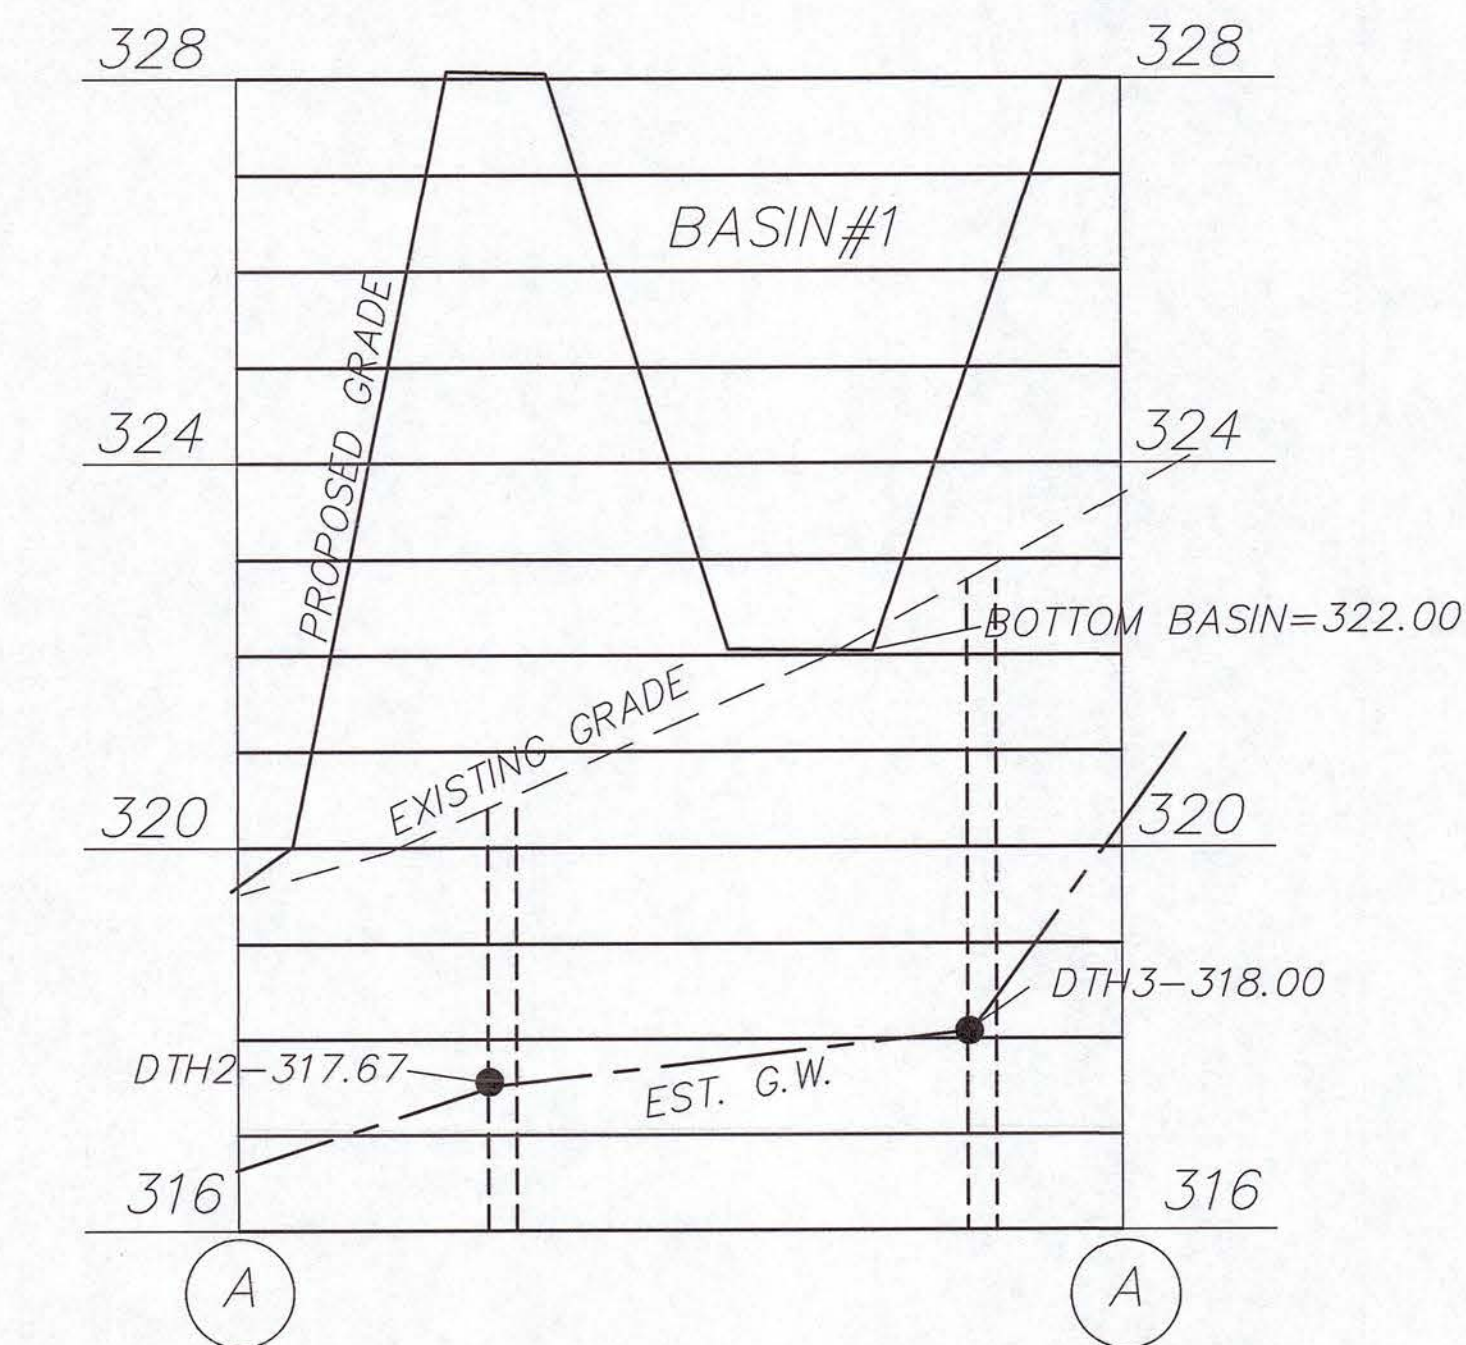


CROSS SECTION A - A

SCALE: 1"=20'(H)
SCALE: 1"=2'(V)

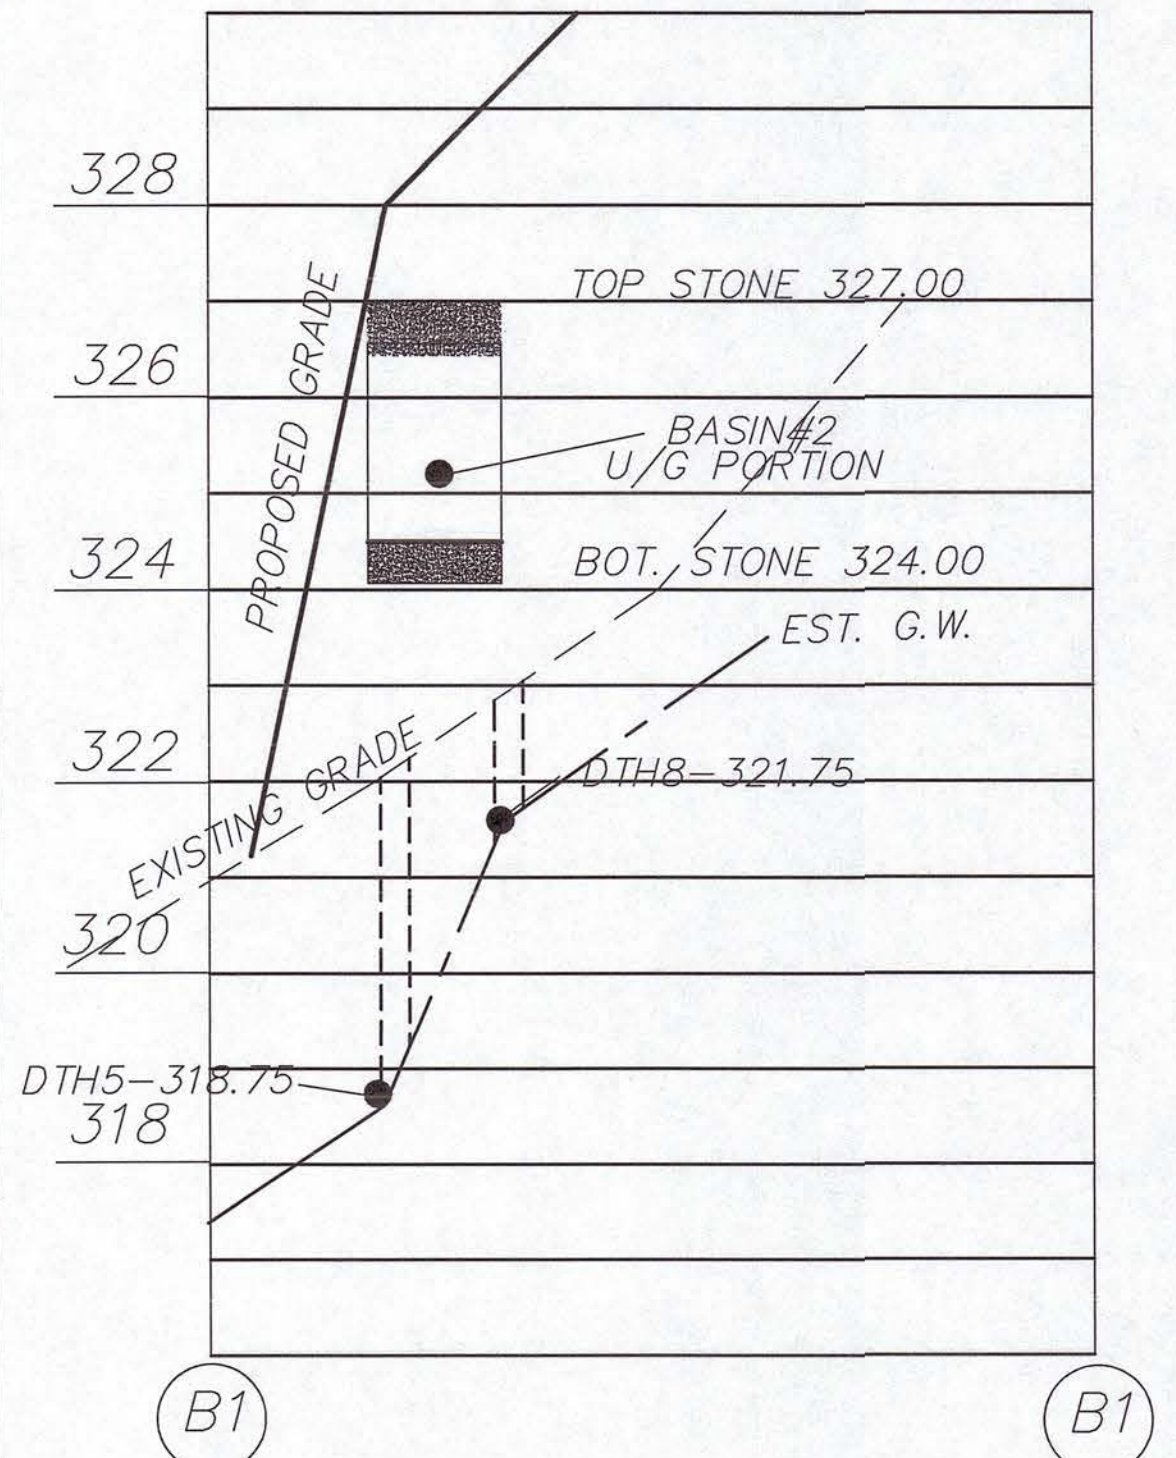


CROSS SECTION B1-B1

SCALE: 1"=20'(H)
SCALE: 1"=2'(V)

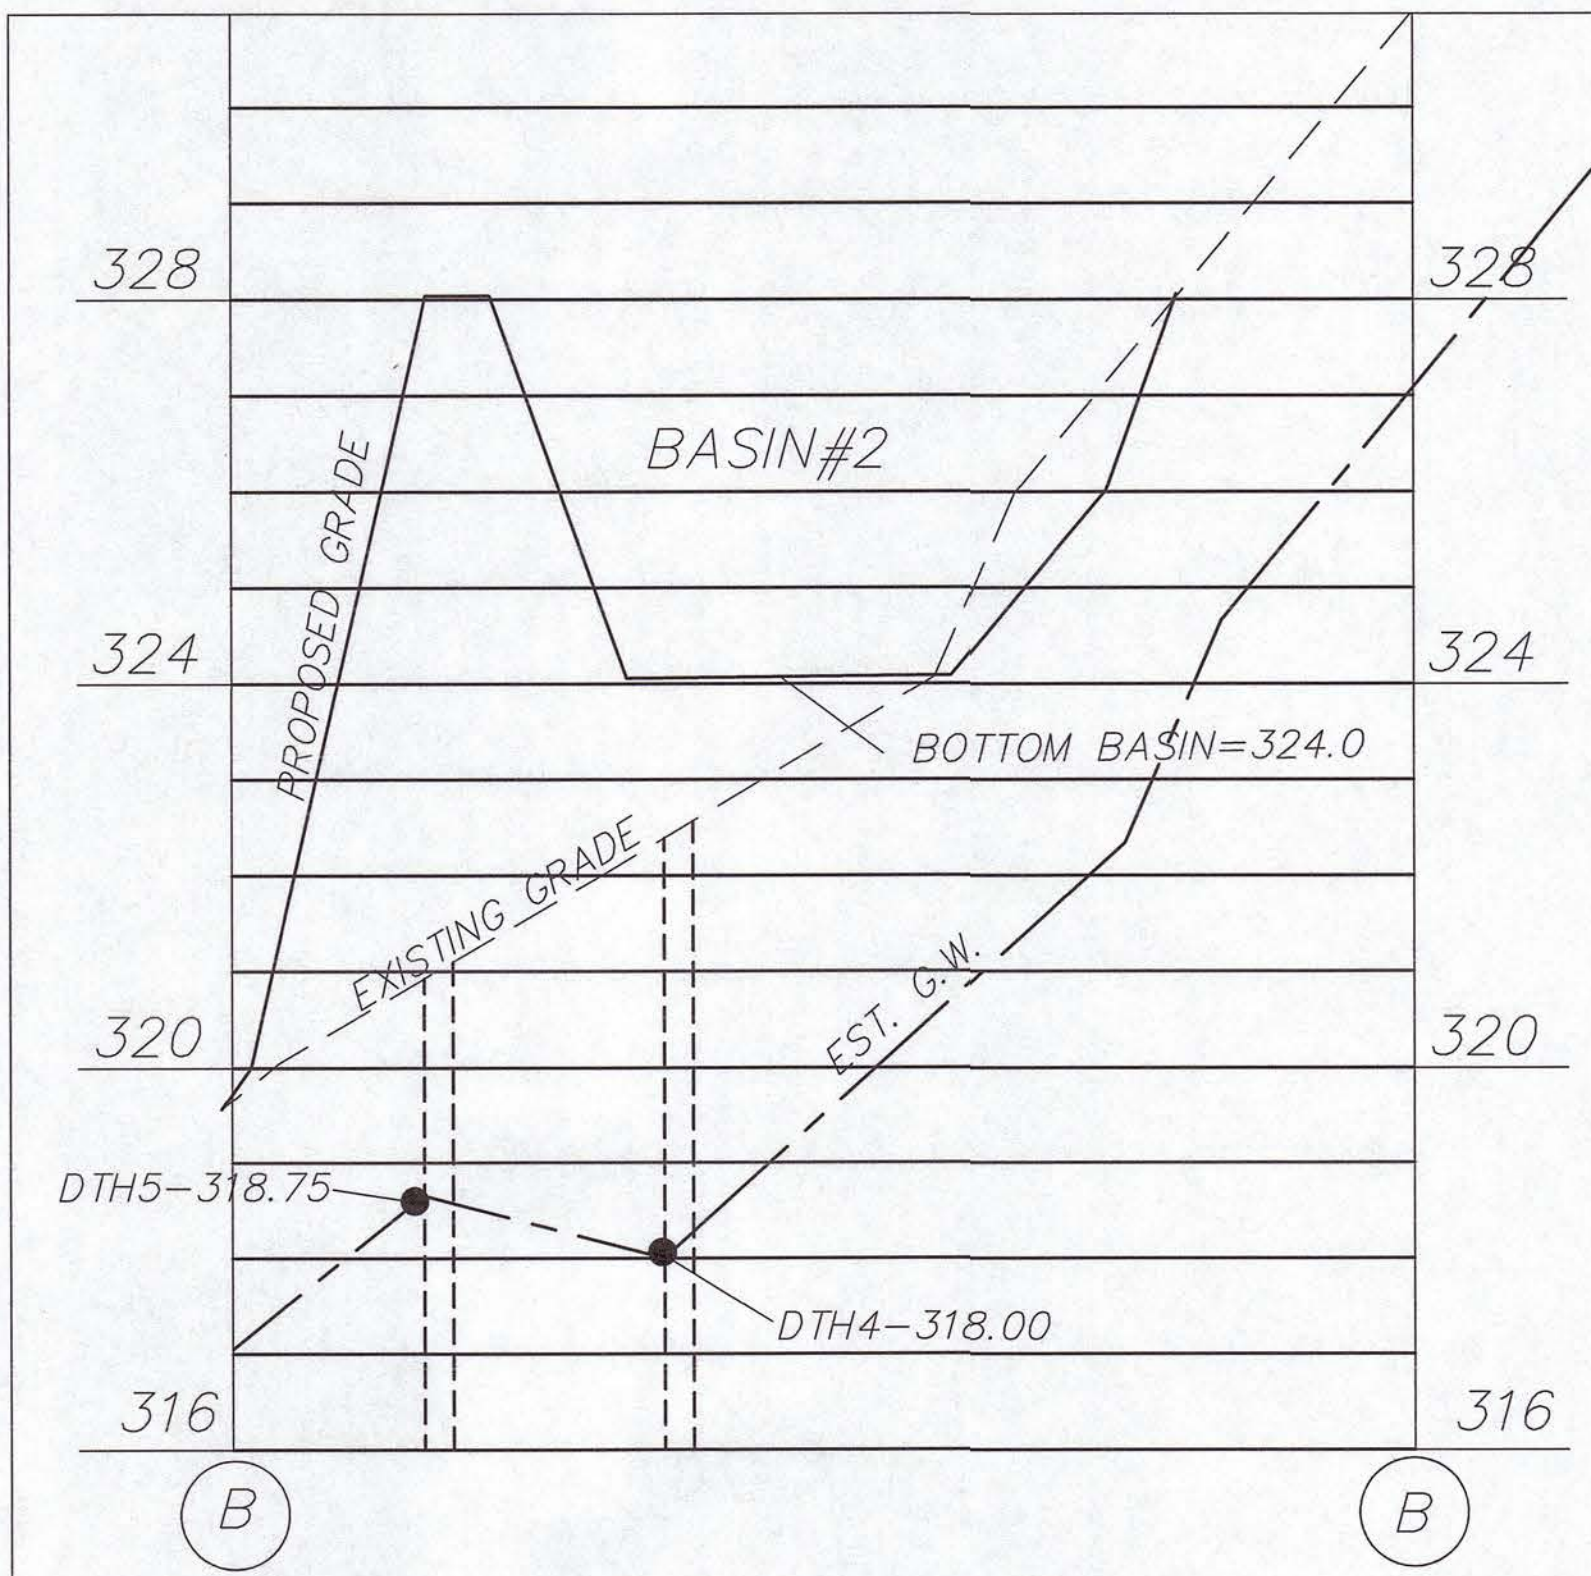

CROSS SECTION B2-B2

SCALE: 1"=20'(H)
SCALE: 1"=2'(V)

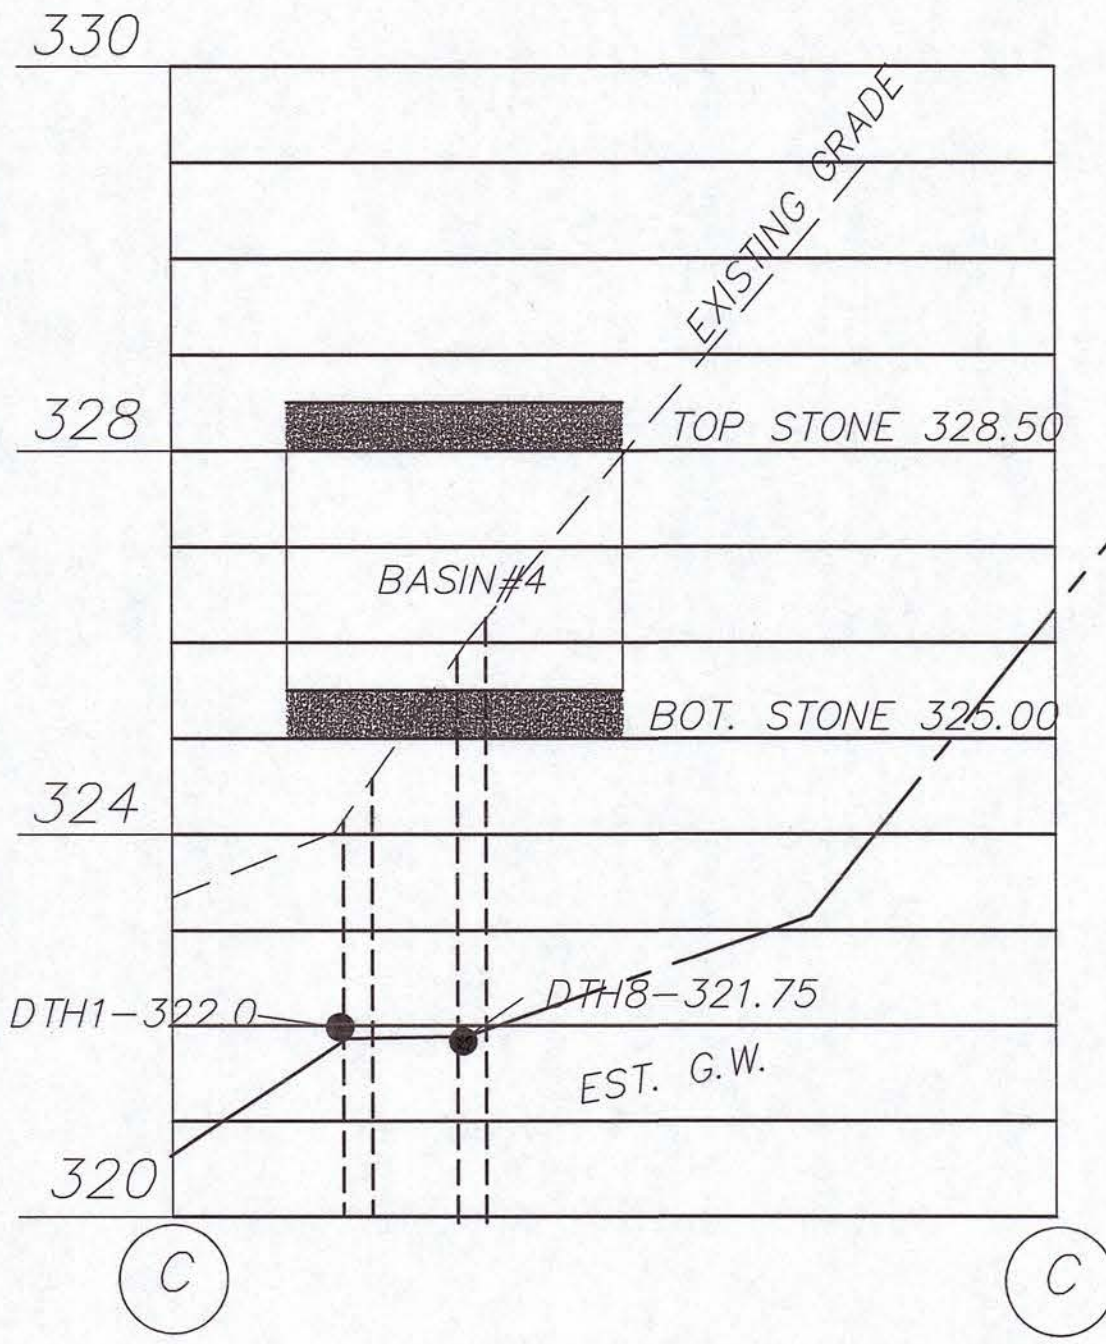

CROSS SECTION C-C

SCALE: 1"=20'(H)
SCALE: 1"=2'(V)

REVISIONS		
REV.	DATE	DESCRIPTION
1	1/8/24	REVISED PLANS.
2	3/25/24	REVISED PLANS

PROJECT NO.	J-016
DESIGNED BY	PML
CHECKED BY	MD
DATE	9/13/23
CAD FILE	J-016 SITE PLAN
PLAN NO.	

APPLICANT/DEVELOPER:
LOBISSER BUILDING CORP.
1 Charlesview Road • Hopedale, MA 01747
P: (508) 478-6235

TITLE:
Upton Apartments
47 Main Street,
Upton Massachusetts
Preliminary
Residential Development Plans
Comprehensive Permit Application
Upton Zoning Board of Appeals

SHEET TITLE



BASIN CROSS SECTIONS

SHEET NO.

C-11.0



P.E.

P.L.S.

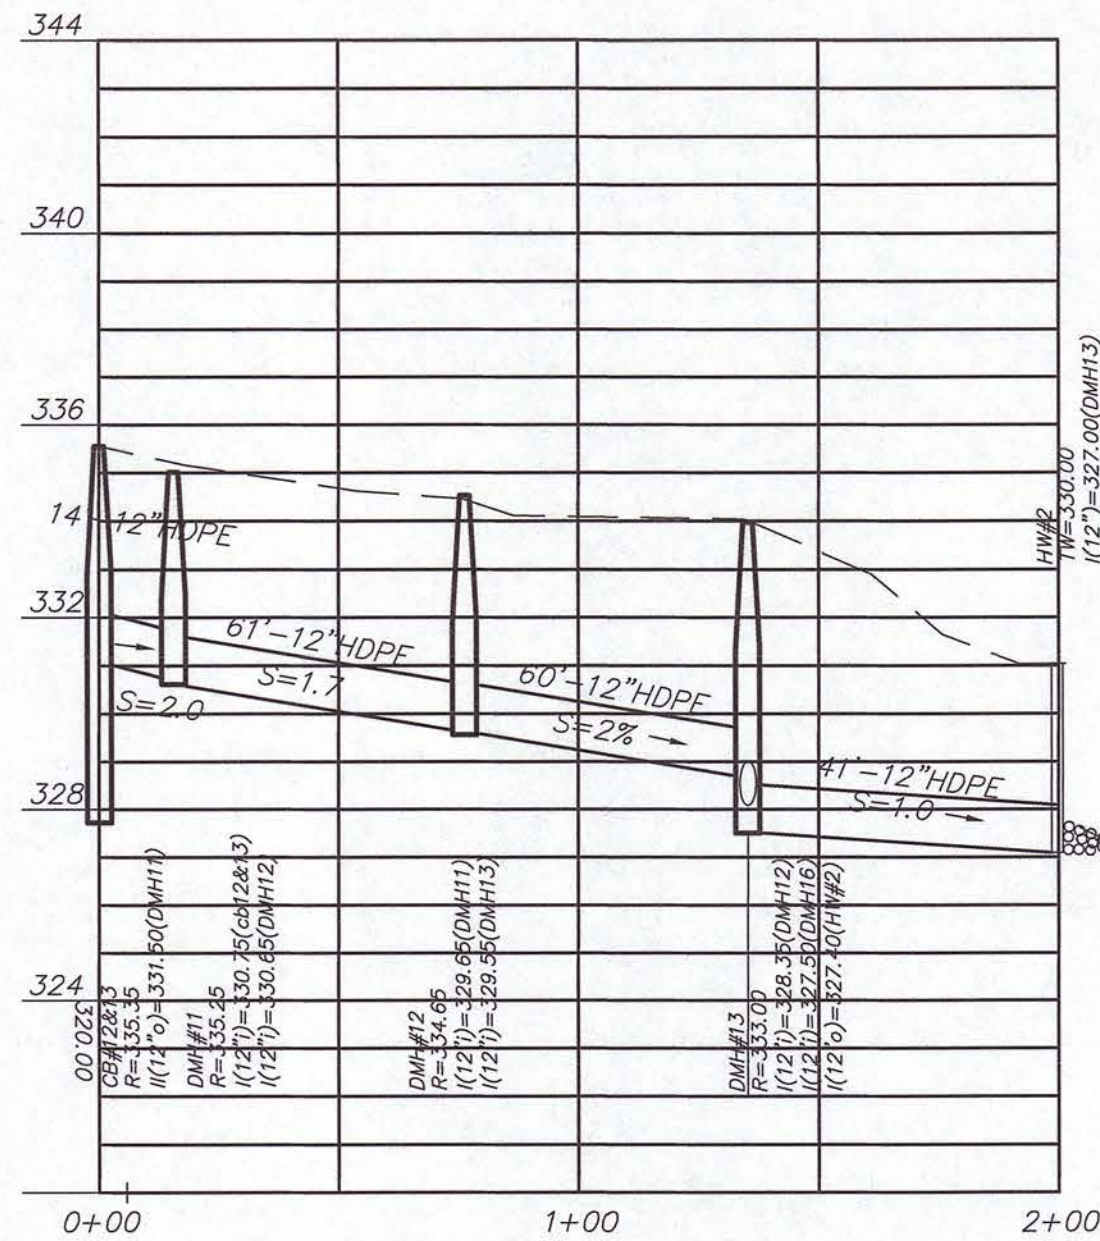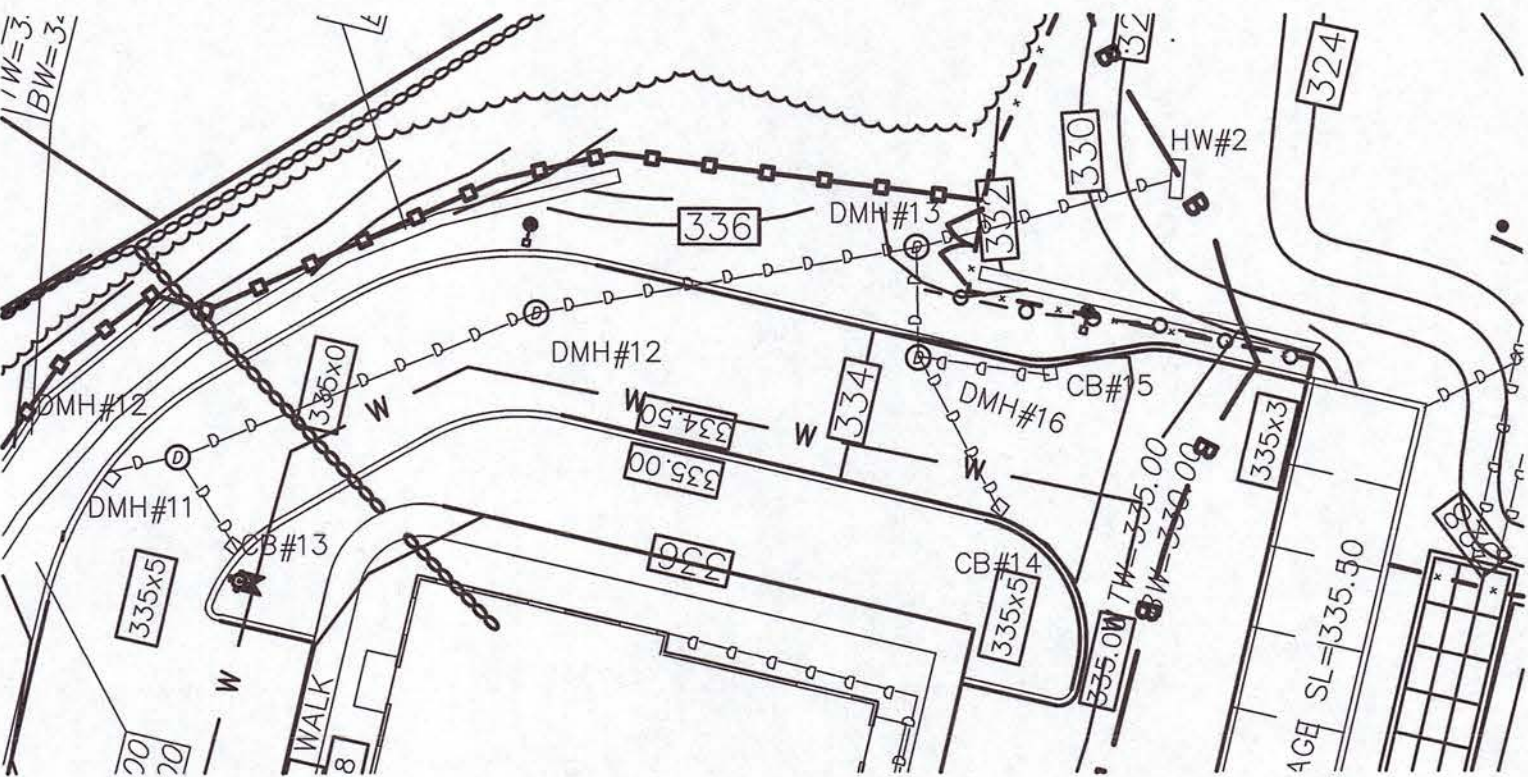

DRAINAGE PROFILE 2

SCALE: 1"=40'(H)
1"=4'(V)

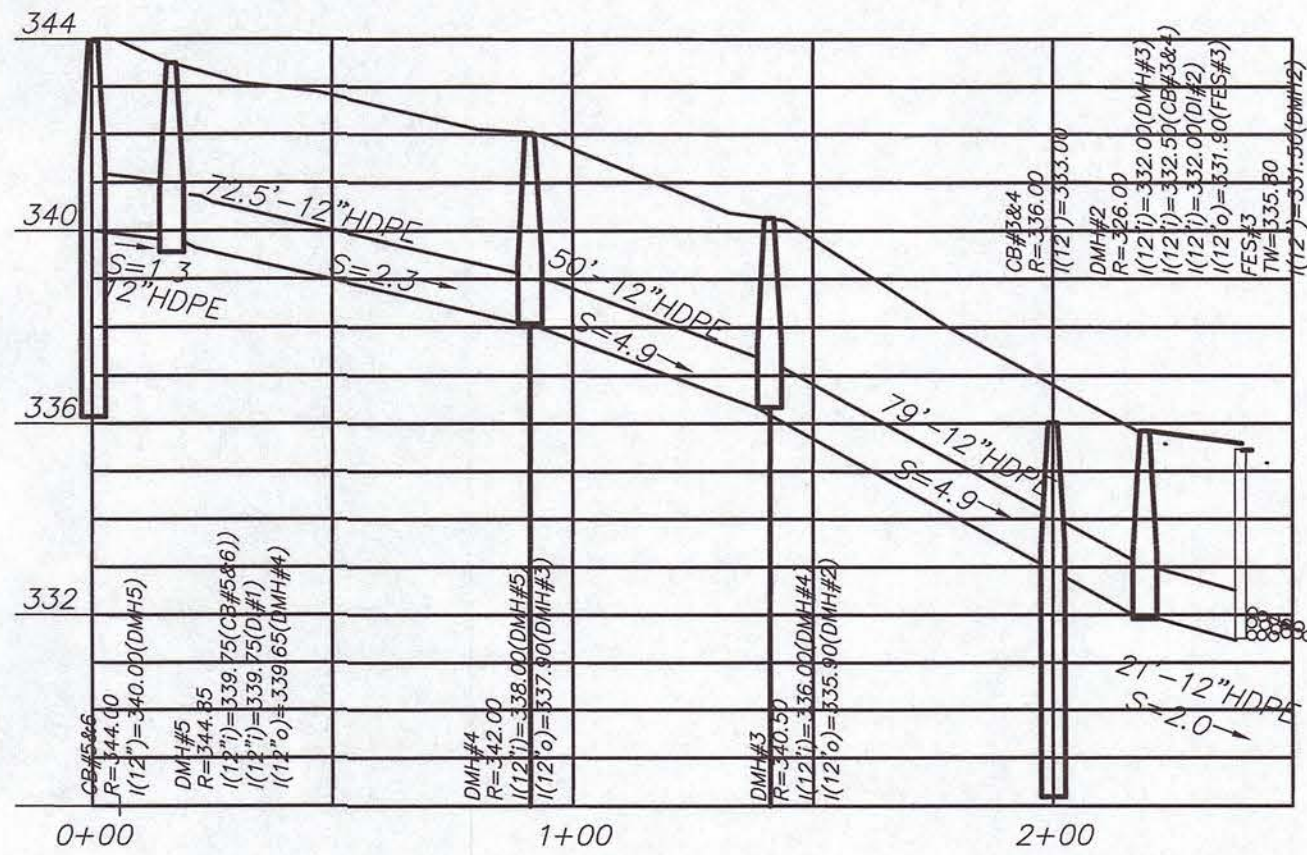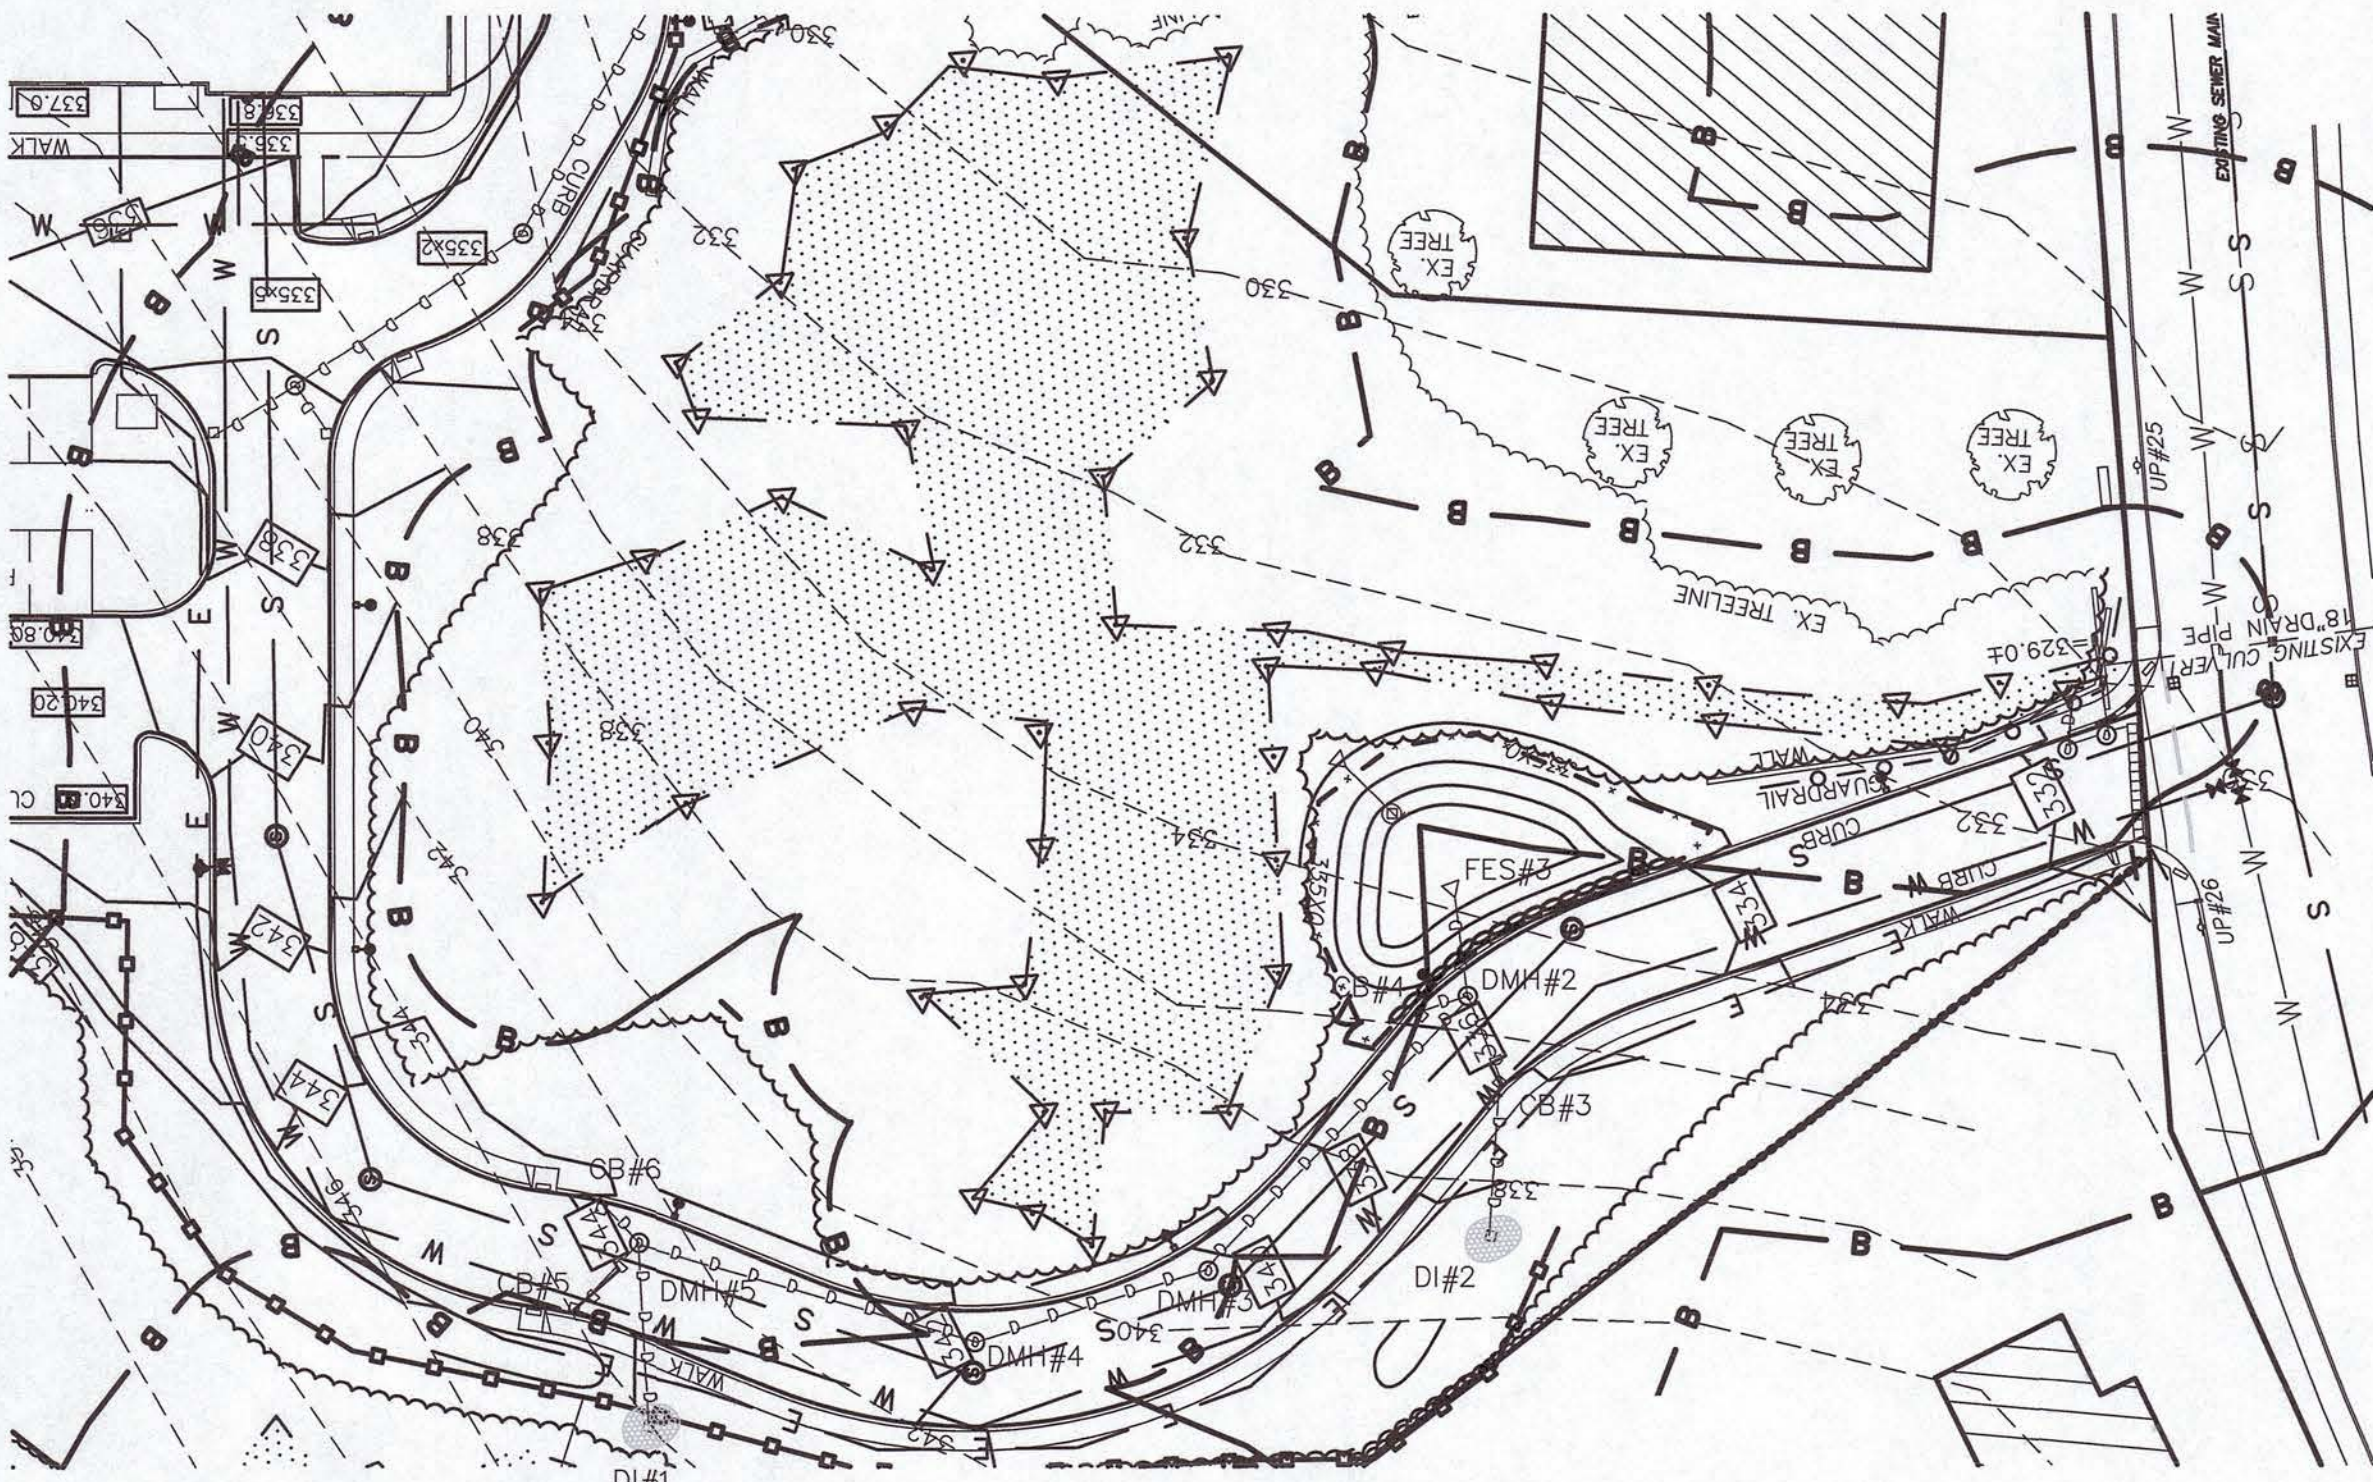

DRAINAGE PROFILE 3




SCALE: 1"=40'(H)
1"=4'(V)

REVISIONS		
REV.	DATE	DESCRIPTION
1	1/8/24	REVISED PLANS.
2	3/25/24	REVISED PLANS
PROJECT NO.	J-016	
DESIGNED BY	PML	
CHECKED BY	MD	
DATE	9/13/23	
CAD FILE	J-016 SITE PLAN	
PLAN NO.		

APPLICANT/DEVELOPER:
LOBISSER BUILDING CORP.
1 Charlesview Road • Hopedale, MA 01747
P: (508) 478-6235


TITLE:
Upton Apartments
47 Main Street,
Upton Massachusetts
Preliminary
Residential Development Plans
Comprehensive Permit Application
Upton Zoning Board of Appeals

SHEET TITLE
PROFILE SHEET
SHEET 2 OF 2
SHEET NO.
C-12.2

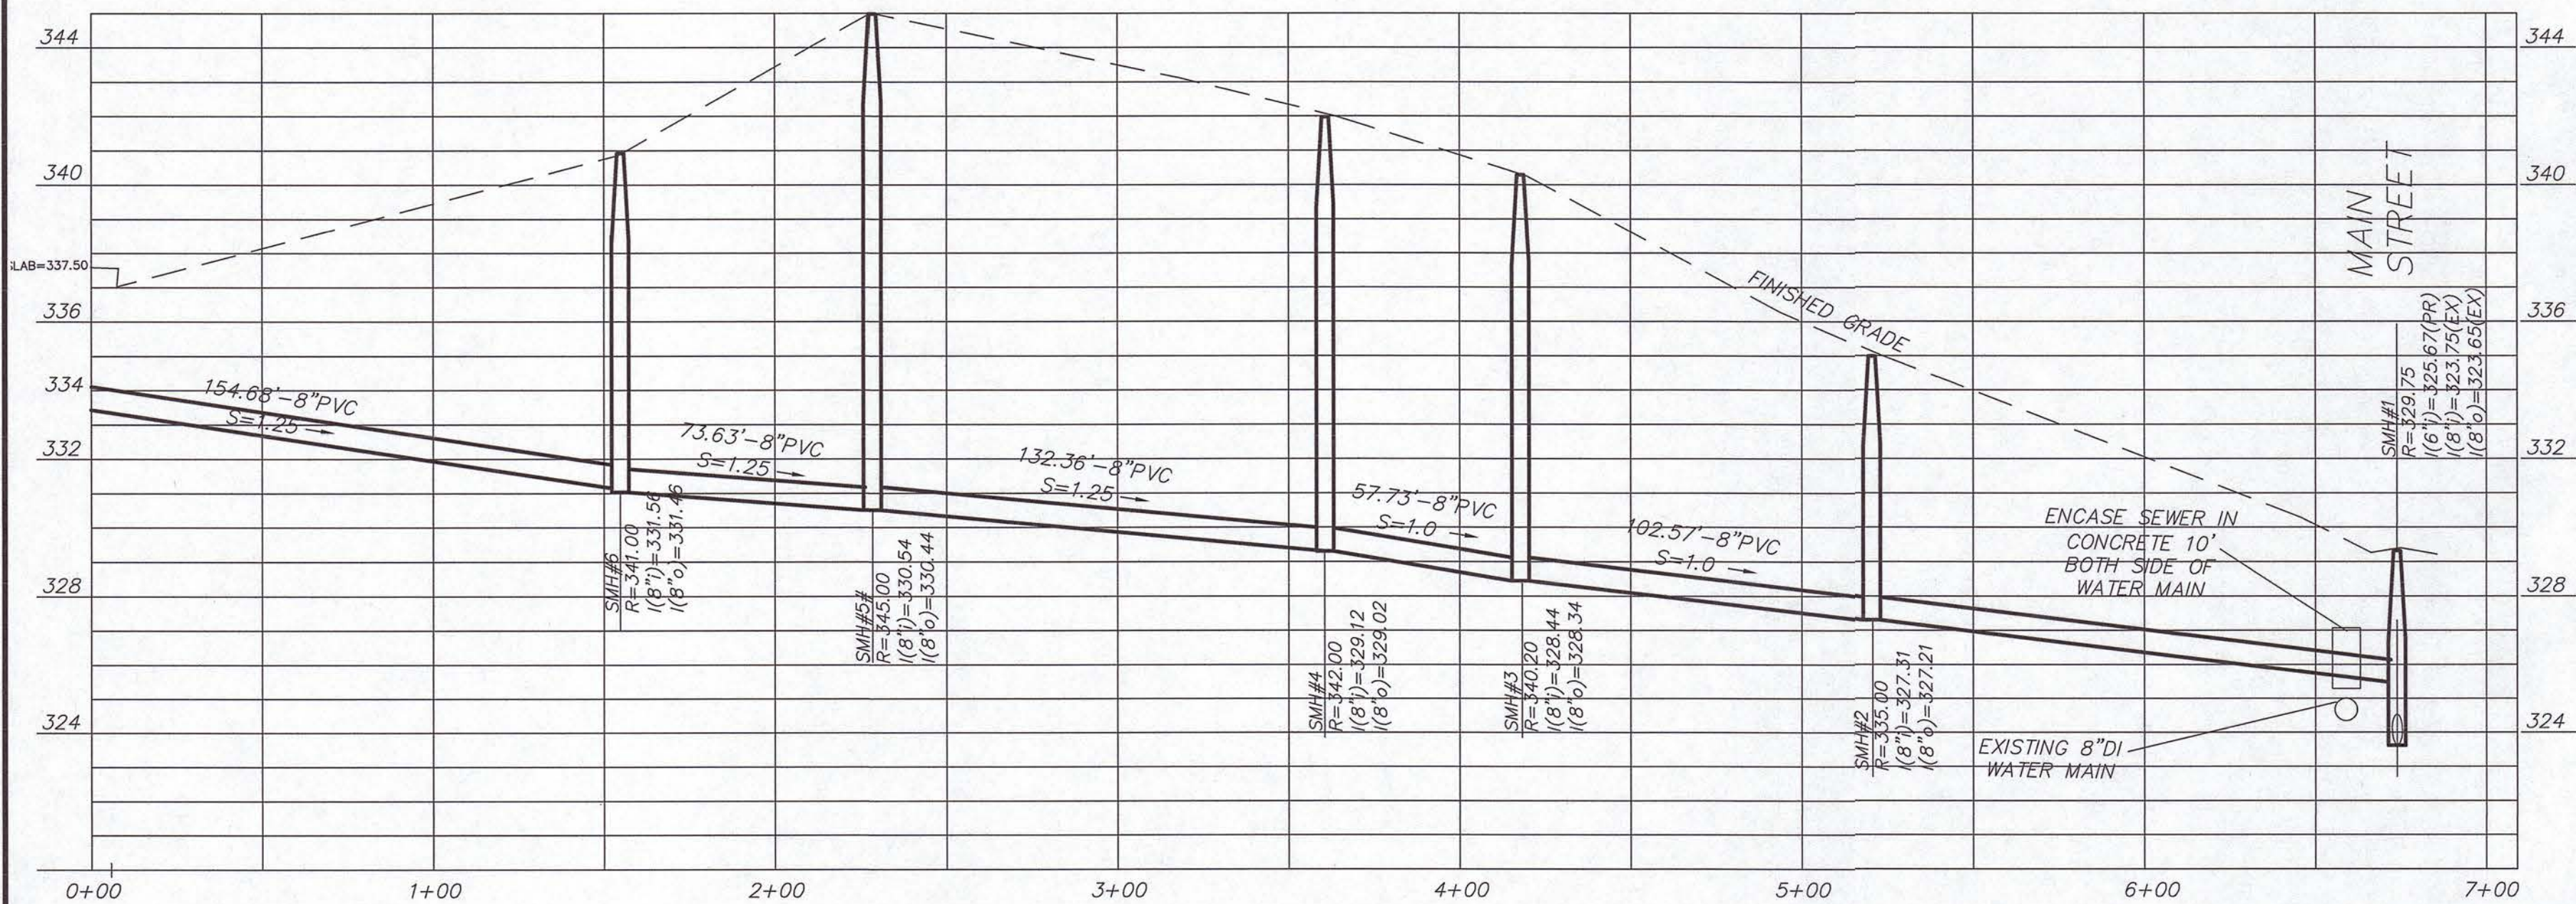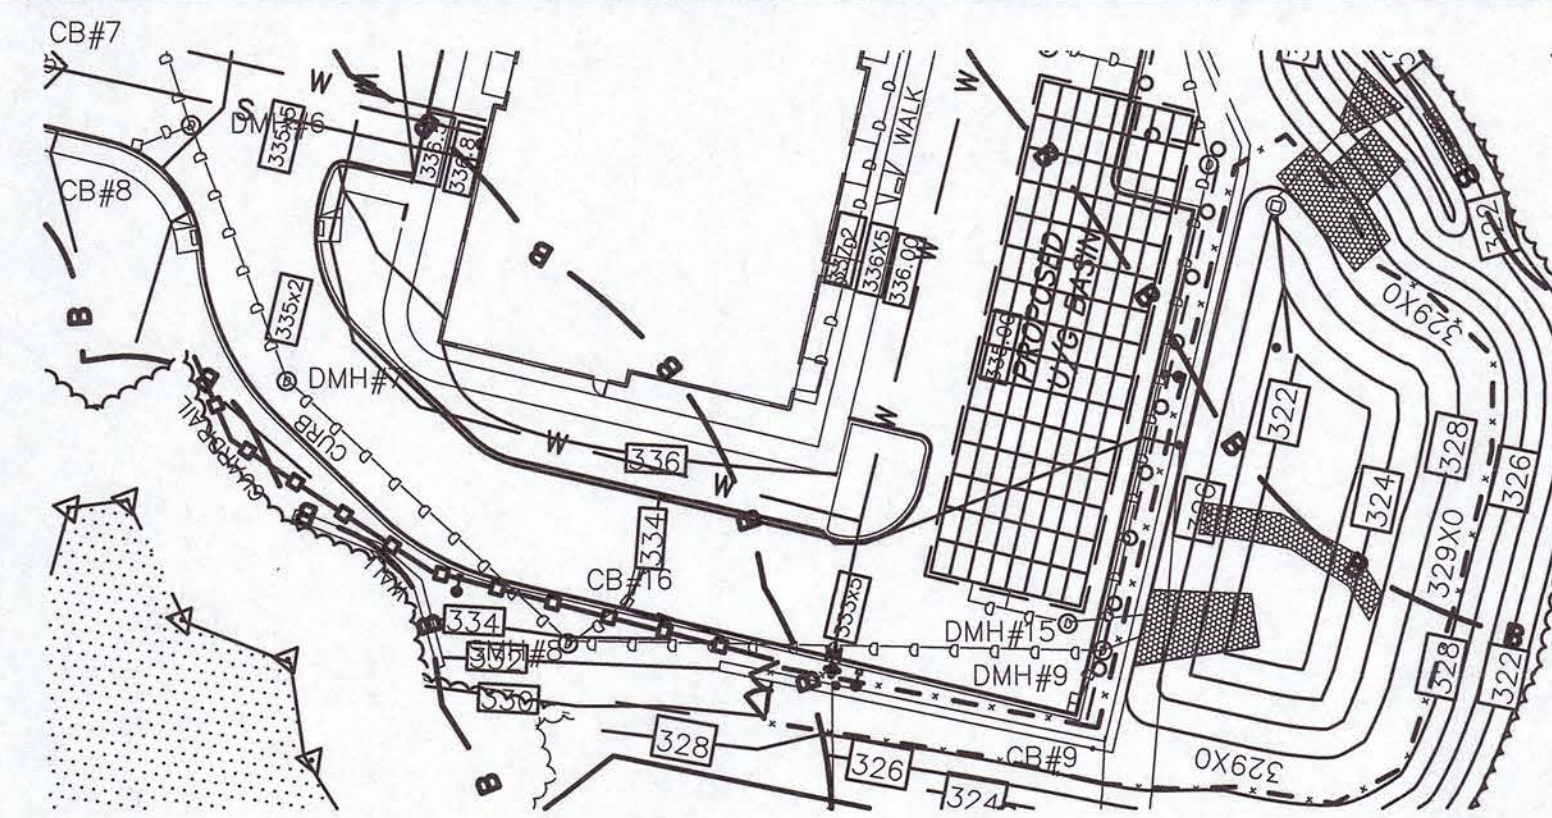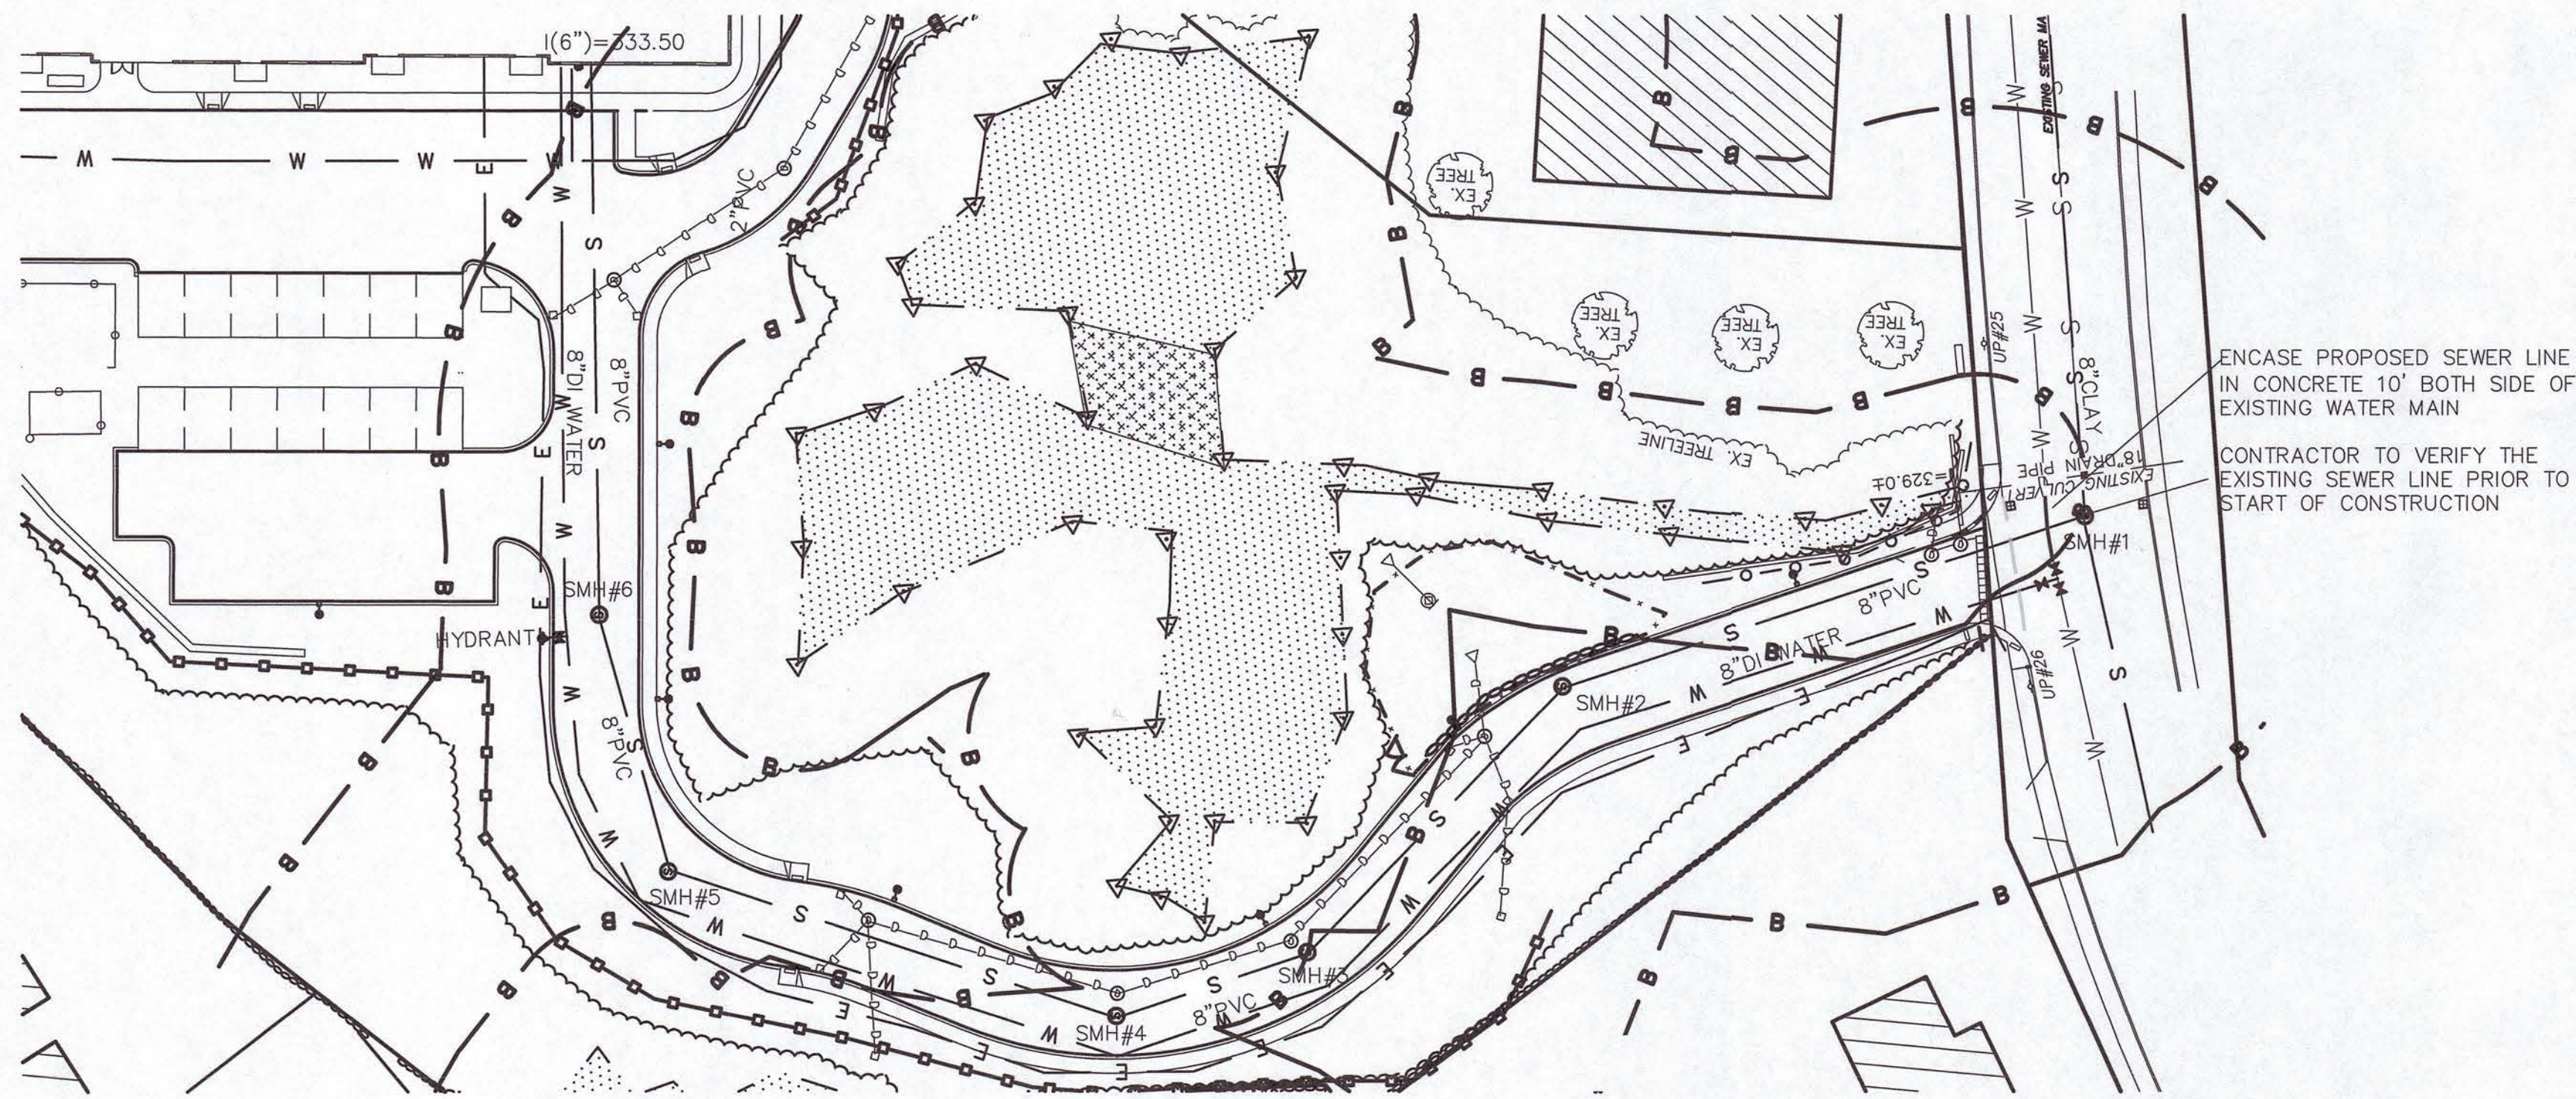



SEWER PROFILE

SCALE: 1"=40'(H)
1"=4'(V)

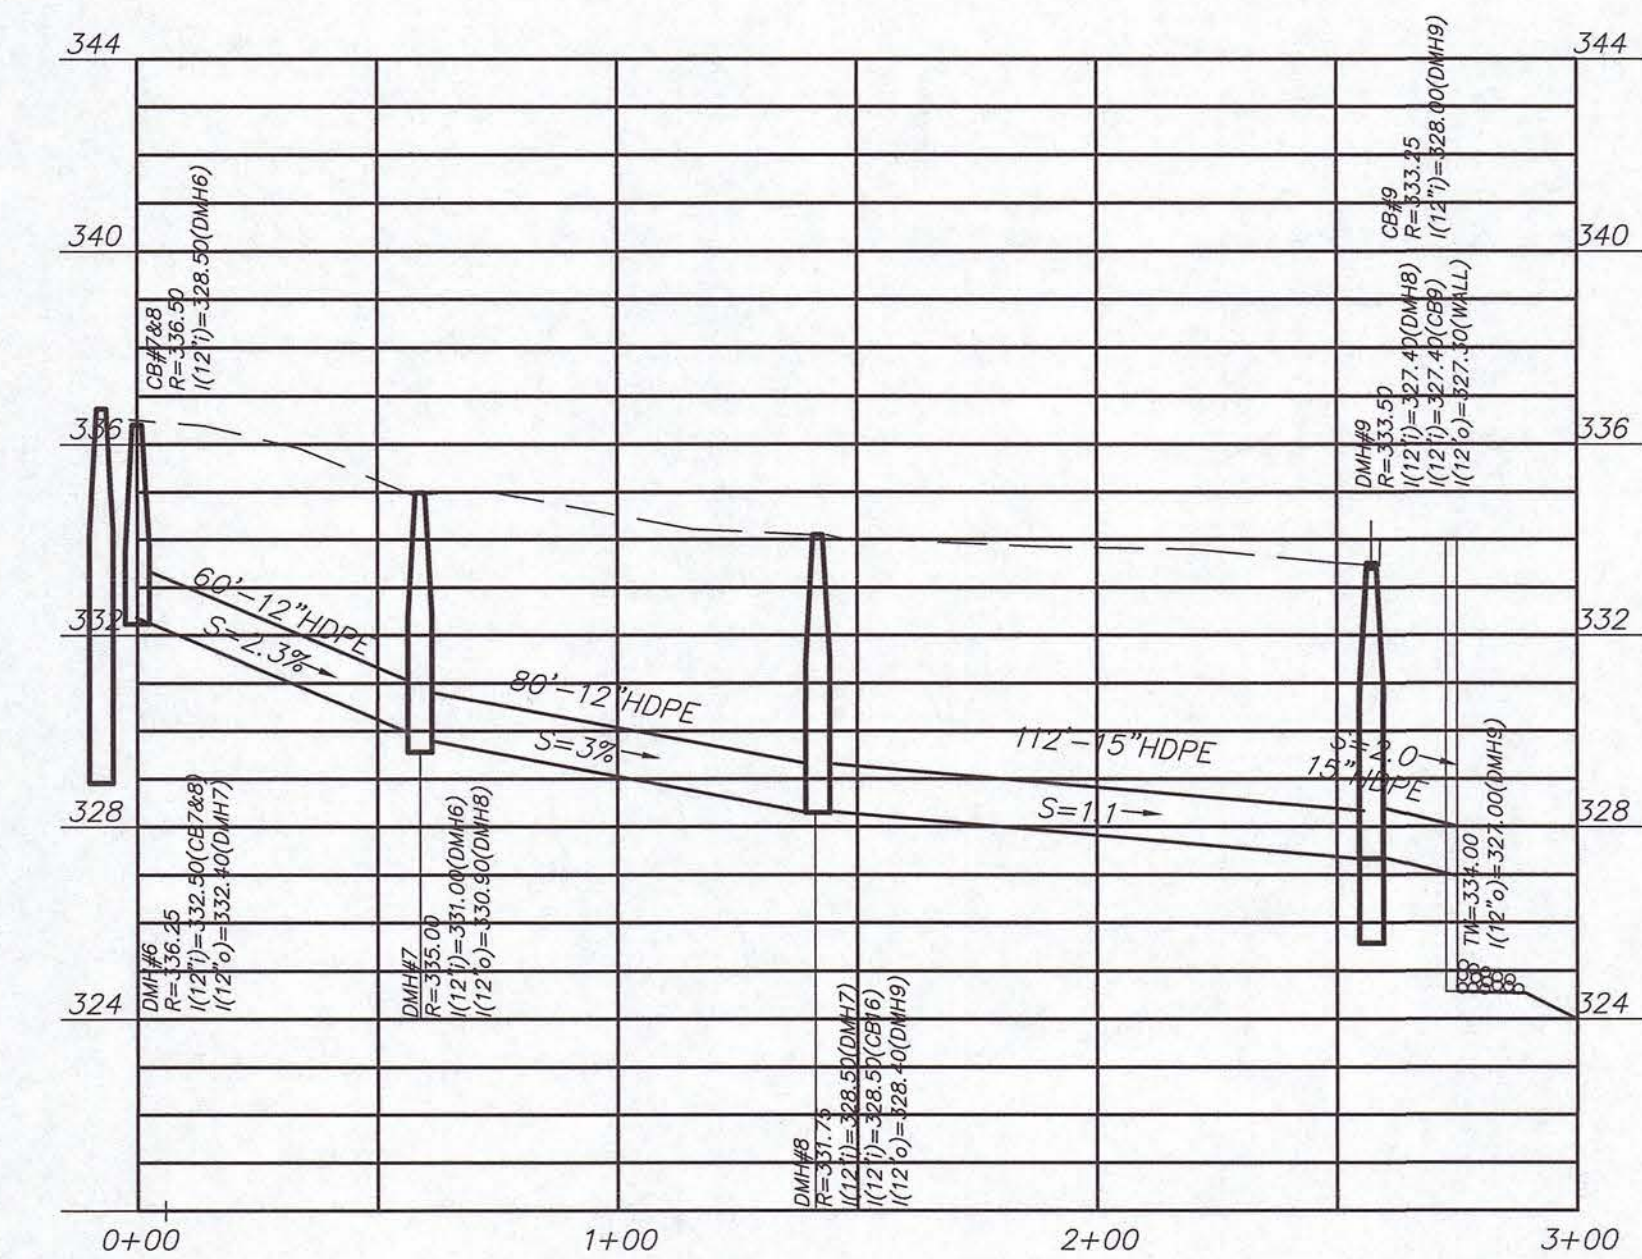

DRAINAGE PROFILE 1A

SCALE: 1"=40'(H)
1"=4'(V)

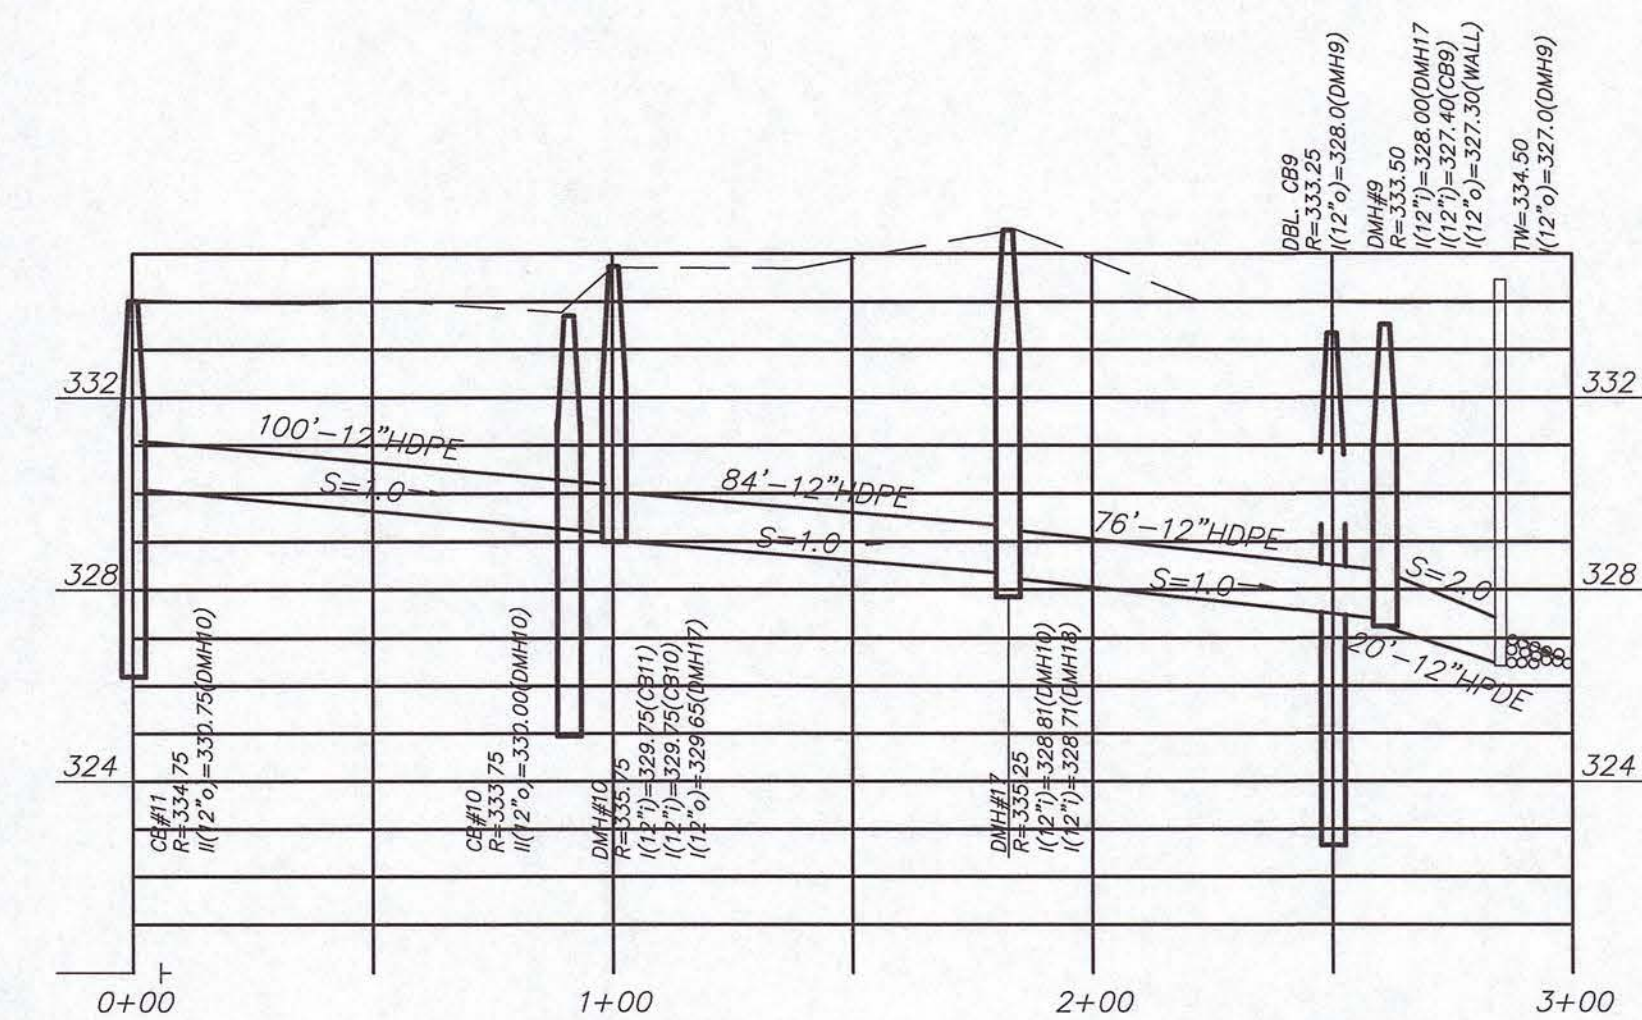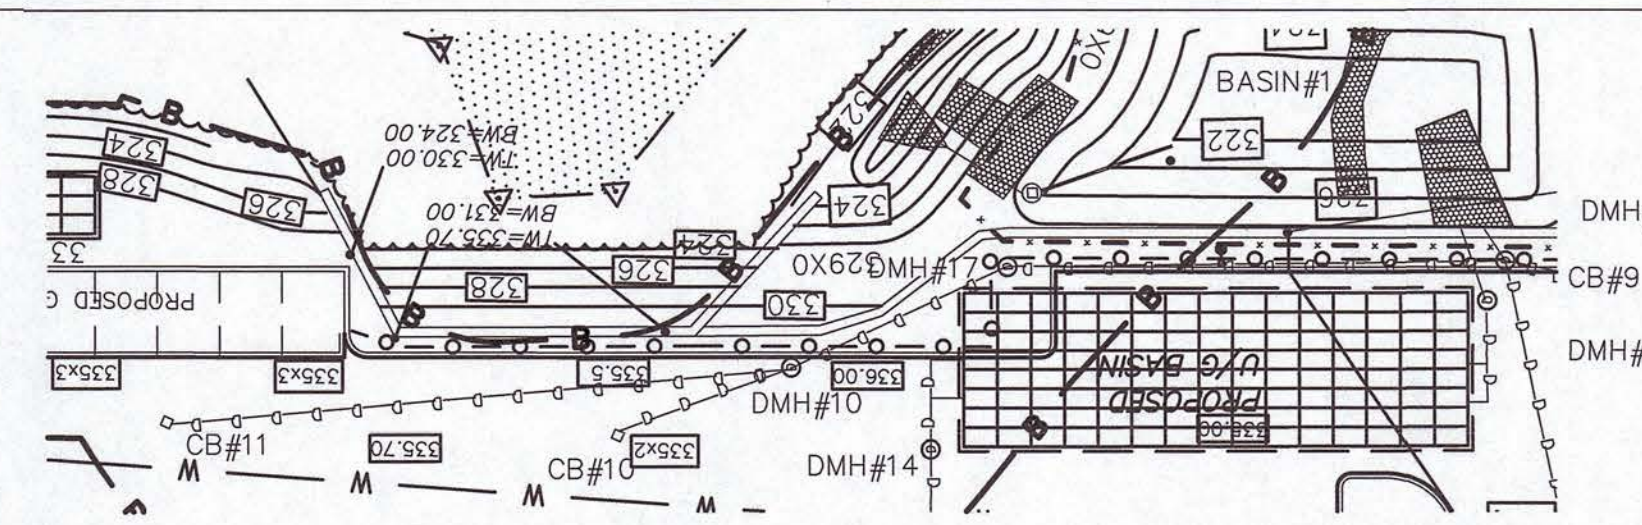

DRAINAGE PROFILE 1B

SCALE: 1"=40'(H)
1"=4'(V)

P.E.	P.L.S.
MICHAEL DEAN No. 4628 REGISTERED PROFESSIONAL ENGINEER STATE OF MASSACHUSETTS	

REVISIONS		
REV.	DATE	DESCRIPTION
1	1/8/24	REVISED PLANS.

PROJECT NO.	J-016
DESIGNED BY	PML
CHECKED BY	MD
DATE	9/13/23
CAD FILE	J-016 SITE PLAN
PLAN NO.	

APPLICANT/DEVELOPER:	LOBISSER BUILDING CORP.
	1 Charlesview Road • Hopedale, MA 01747
	P: (508) 478-6235

TITLE:
Upton Apartments
47 Main Street,
Upton Massachusetts
Preliminary
Residential Development Plans
Comprehensive Permit Application
Upton Zoning Board of Appeals

SHEET TITLE
PROFILE SHEET
SHEET 1 OF 2

SHEET NO.
C-12.1